



150%

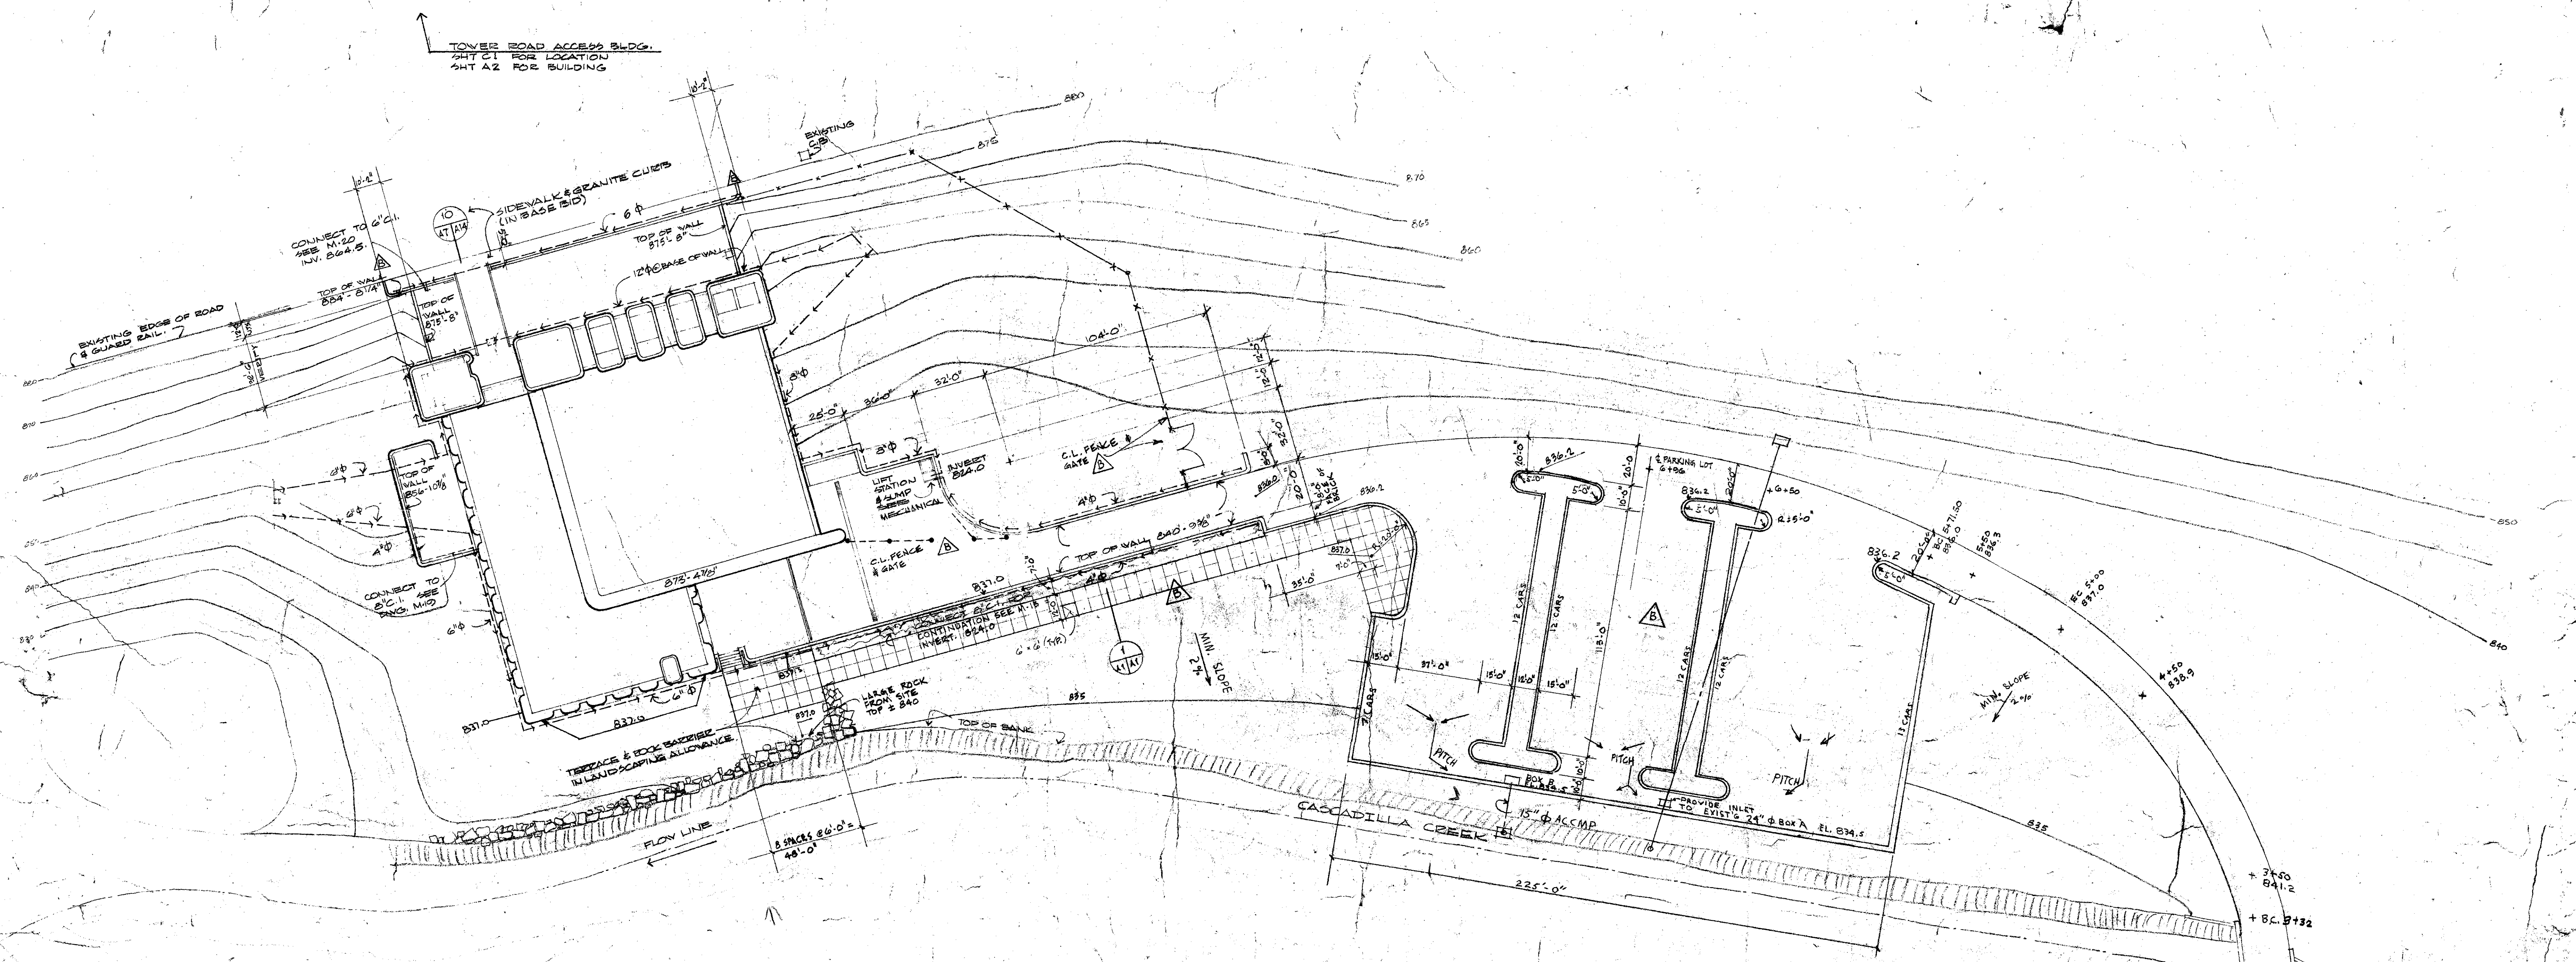

SITE RETAINING WALL & FOUNDATION DRAINAGE PLAN
1" = 30'-0"

NOTE: FOR CIVIL, MECHANICAL
& ELECT. WORK, SEE
OTHER DRAWINGS.

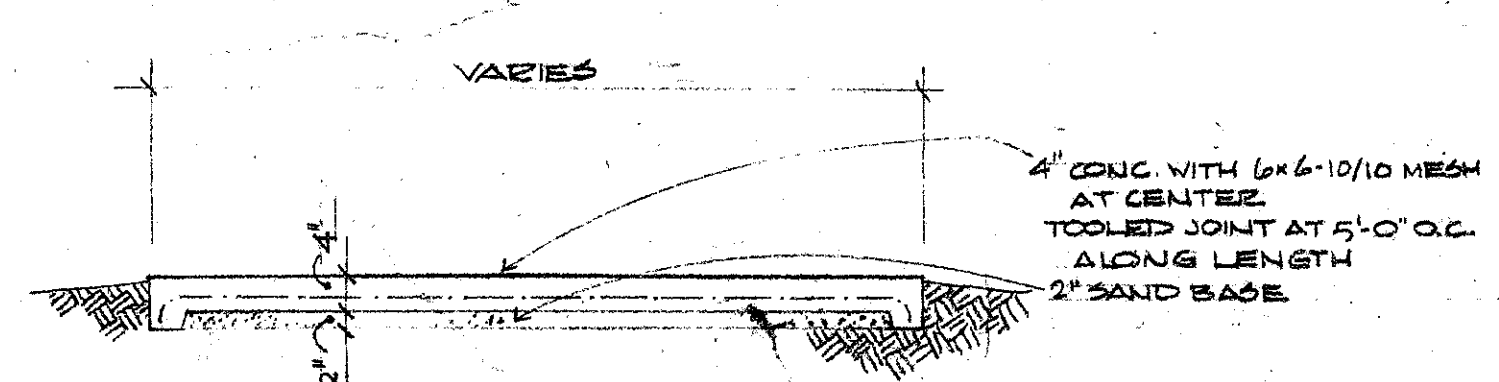

TYPICAL SIDEWALK

ABBREVIATIONS		SYMBOLS	
A.B.C.	FIRE EXTINGUISHER CABINET	SECTION LETTER- DETAIL NUMBER	
AD	AREA DRAIN	SHEET WHERE CUT	
EDF	ELECTRIC DRINKING FOUNTAIN	SHEET WHERE DE- TAILED OR DRAWN	
EXT.	EXTERIOR	ROOM NUMBERS	
FB	FACE OF BECK	DOOR NUMBERS	
FC	FACE OF CONCRETE	MODULE INTERSECTIONS	
FD	FLOOR DRAIN	SUSPENDED ACETILE CEILING	
PHMS	PLAT HEAD MACHINE SCREEN	SEE NOTE SHEET A-5	
FS	FACE OF STUD	VD STUD & GYP BD PARTITION	
1/2 FS	ONE-HALF FULL SIZE	SEE TYP. CONDIT'N SH. A-2.1	
HC	HOLLOW CORE	CONC. BLOCK - SIZE AS NOTED	
HWD	HARDWOOD	BECK VENEER	
RFD	RECESSED FLOOR DRAIN	STEEL	
SC	SOLID CORE	BRONZE	
SHMS	SH. HEAD MACHINE BOLT	CONCRETE	
SM	SH. METAL SCREEN	2" INSULATED WALL	
TC	TRENCH COVER	SEE SH. A-2.1	
TD	TRENCH DRAIN	1/2" STUD & GYP BD PARTITION	
TSD	TUBE SLEEVE OVERFLOW	PLYWOOD PARTITION	
TYARD	TRANSFORMER YARD	SEE SH. A-2.1	
W.D.	WATCHMAN STATION		

AS BUILT	4-1-88	7-1-88
SEE APPENDUM NO. 1	3-8	THE
LTR	REVISIONS	DATE CHK'D APP'D
	BY	APP'D

**IO GEV CORNELL
SYNCHROTRON LABORATORY**
CORNELL UNIVERSITY
ITHACA, NEW YORK

WILLIAM M. BROBECK AND ASSOCIATES
IAN MACKINLAY, AIA ARCHITECT
PREGNOFF & MATHEU STRUCTURAL ENGR.
JACOBS ASSOCIATES CONSTRUCTION ENGR.
950 GILMAN ST. BERKELEY, CALIF. 94710-
TELEPHONE 415-524-8664

DR. GW. / BD. CHK.	1 SUP.	SCALE 1" = 30'-0"
RELEASED	APPROVED	SHEET 6 OF 10.2
LAB NUCLEAR STUDIES		DRAWING NO. A1
DATE FOR REVIEW	DATE FOR REVIEW	WMB & NO. 111-5
2085-33-65-001	044 207 Cornell University B. & P.	110