
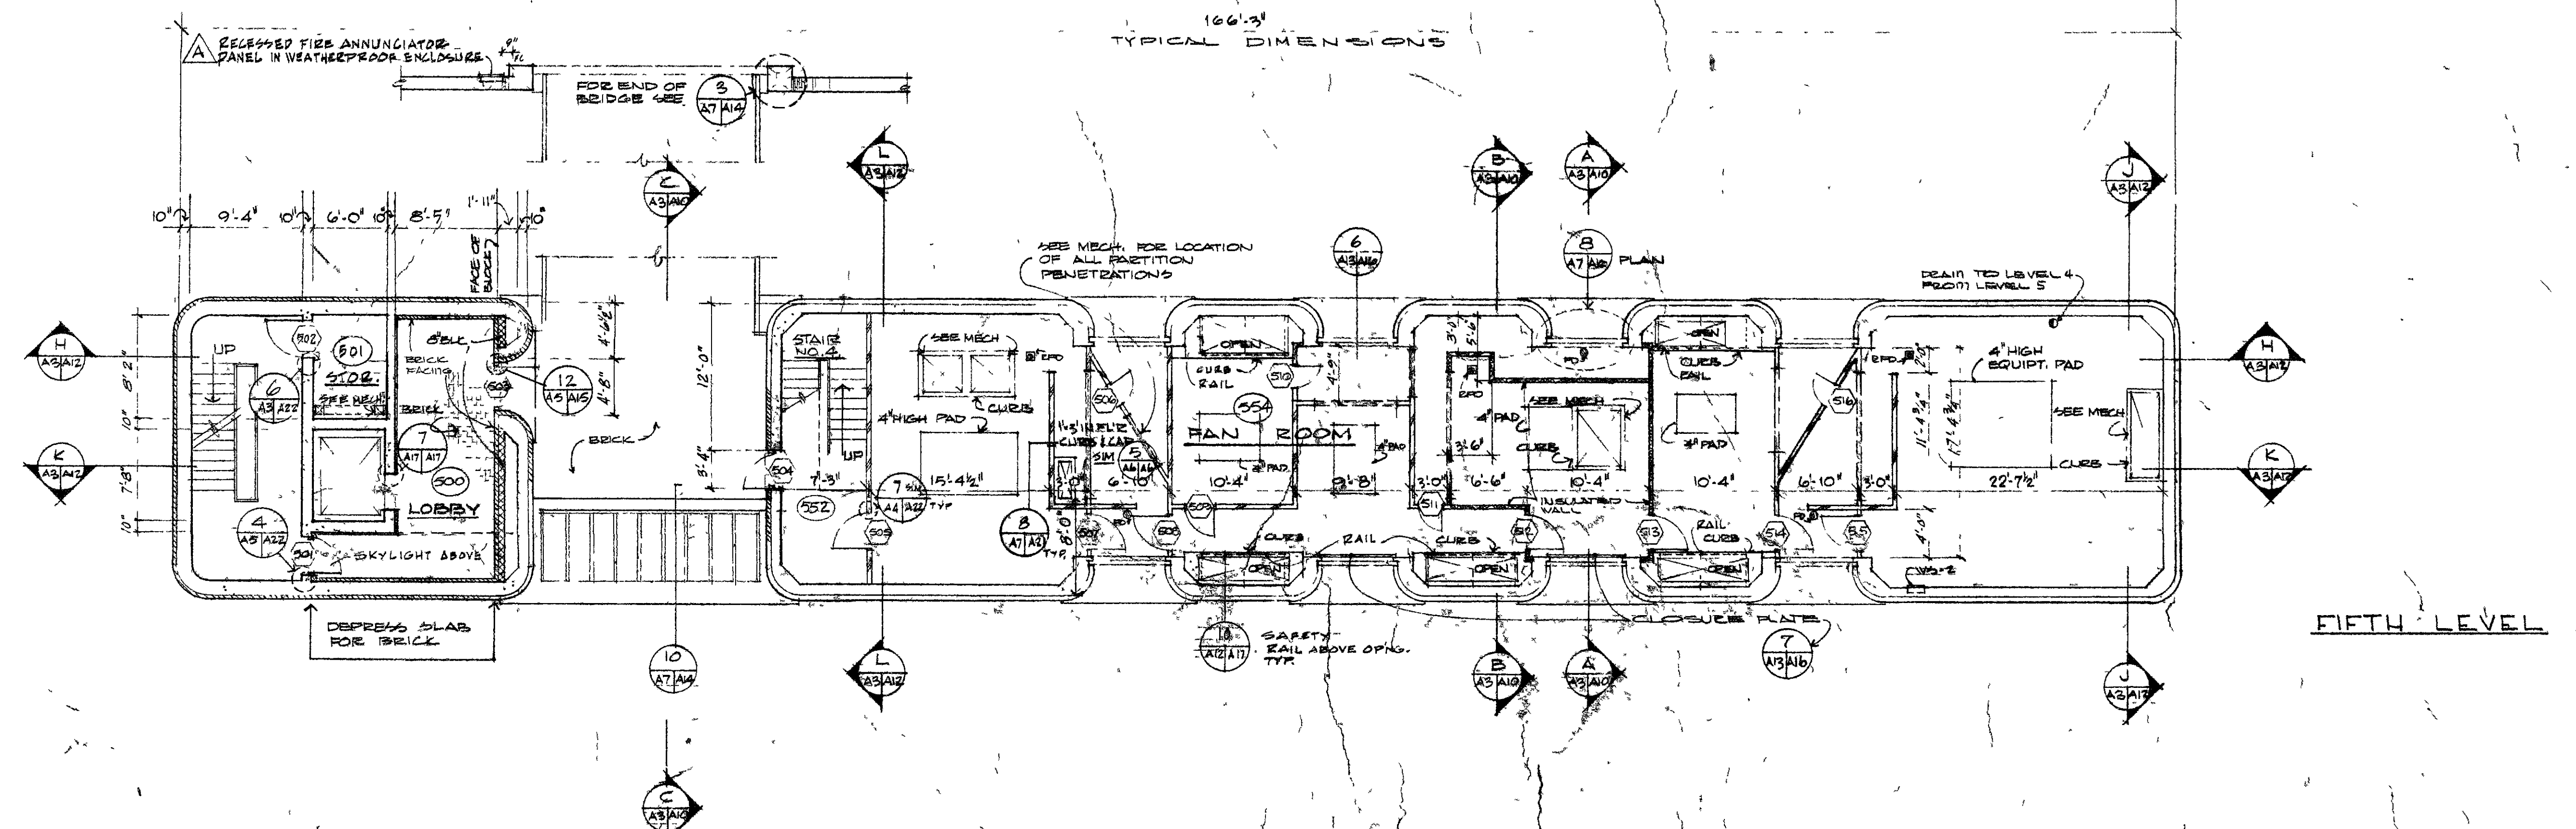
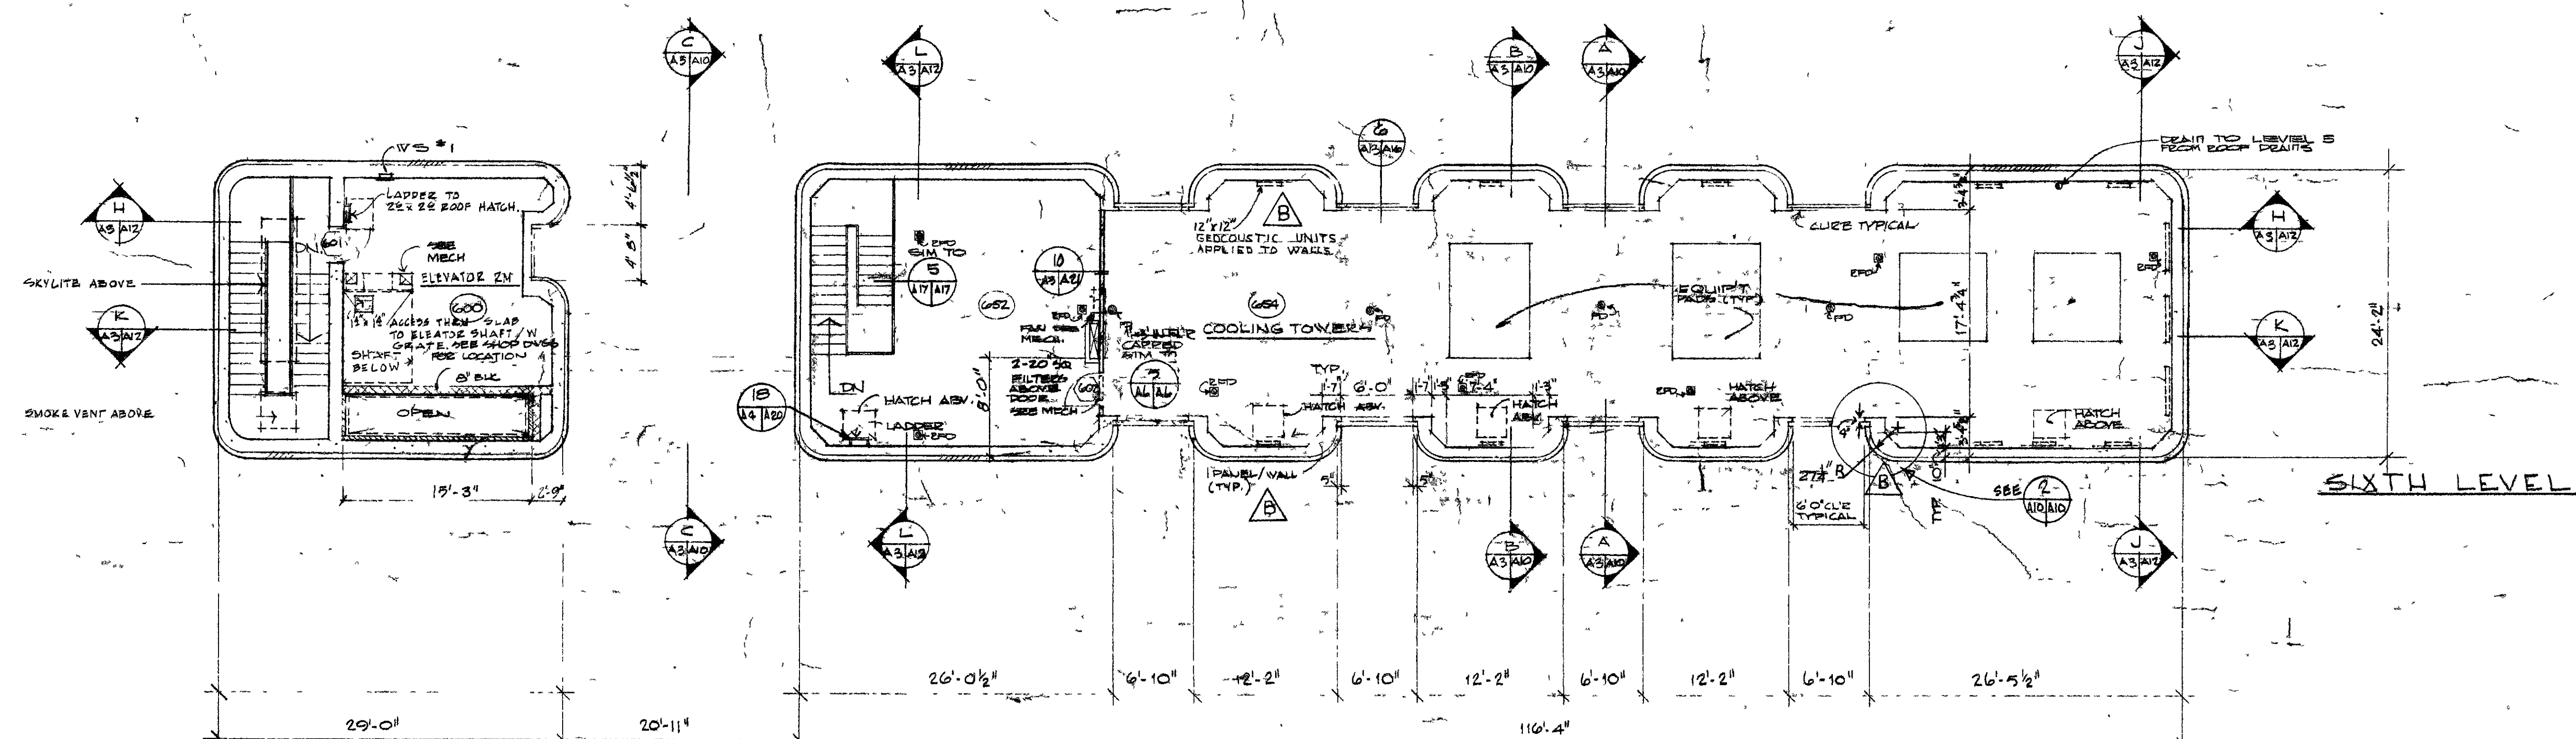


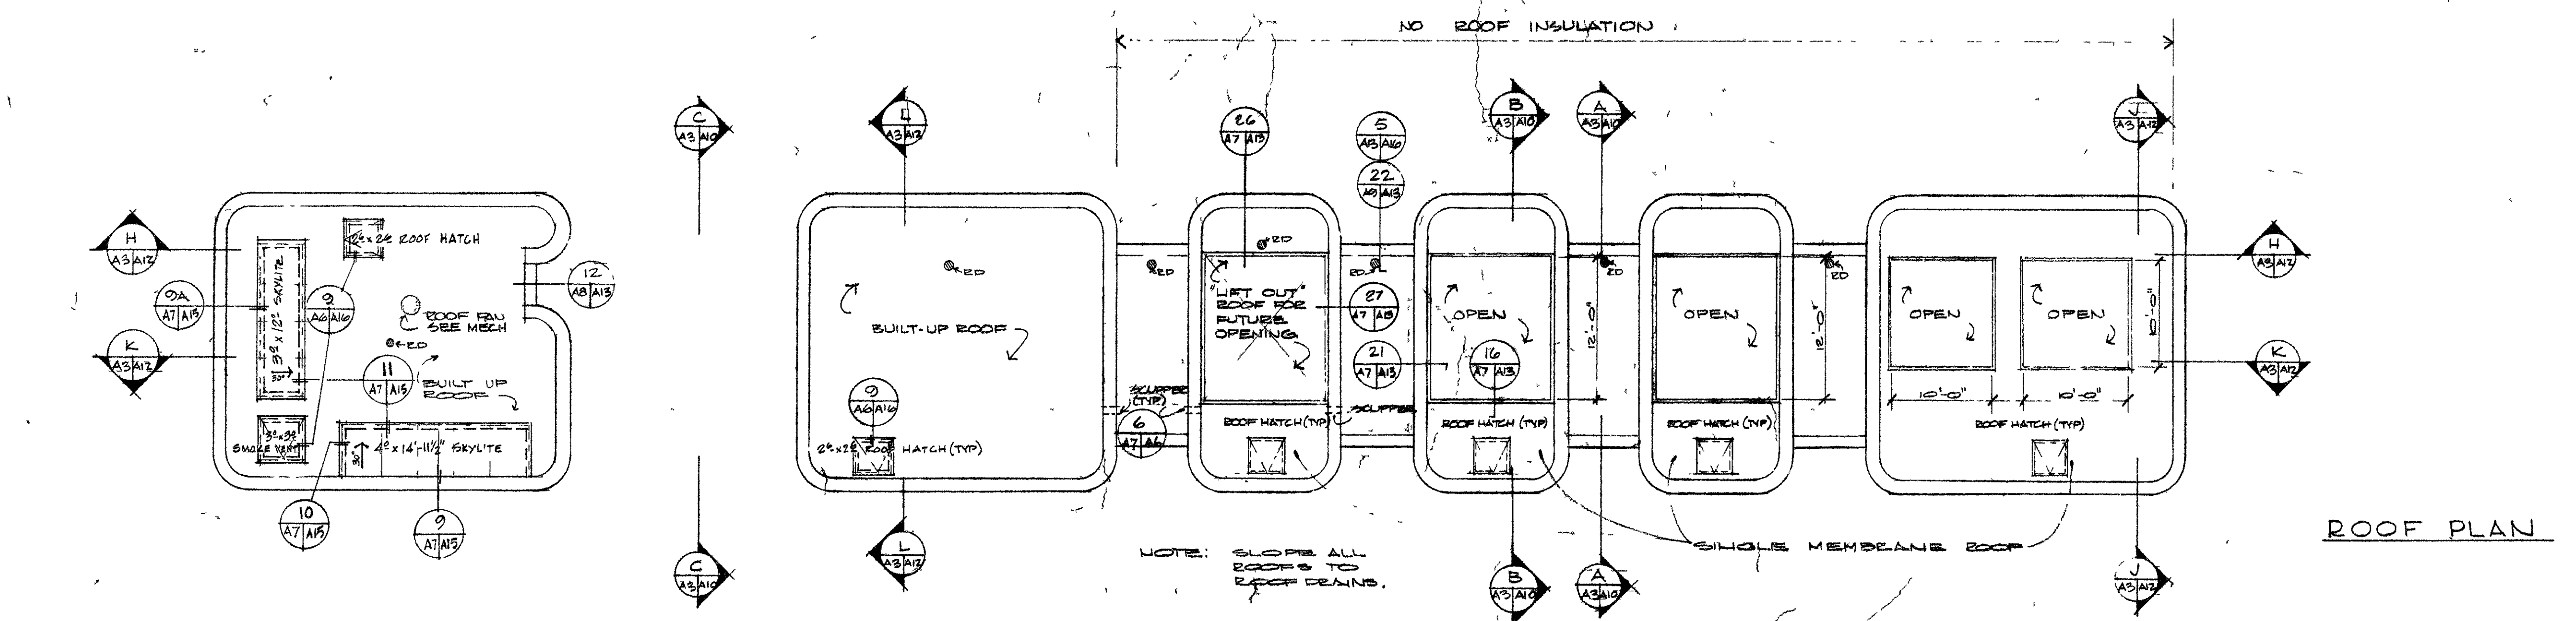

A	AS BUILT.	4-4	J.G.	J.G.	J.G.
A	SEE APPENDUM No.1				
LTR	REVISIONS	DATE	BY	CH'D	APP'D
				APPD	

IO GEV CERN

SYNCHROTRON LABORATORY

CORNELL UNIVERSITY

ITHACA NEW YORK



ROOF PLAN

SIXTH LEVEL

FIFTY LEVEL


 
 
WILLIAM M. BROBECK AND ASSOCIATES

IAN MACKINLAY, AIA
PREGNOTCH & MATHEW
JACOBS ASSOCIATES

950 GILMAN ST.
TELEPHONE

ARCHITECT
STRUCTURAL ENGR.
CONSTRUCTION ENGR.

BERKELEY, CALIF. 94710
415 - 524 - 8664

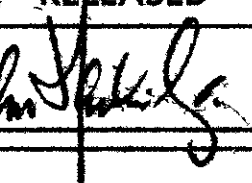DR.GR./BD	CHK.	SUPV.	SCALE
RELEASED		APPROVED	1/8" = 1' 0"
		SHEET 12 OF 102	
		DRAWING NO. A7	
		V.P.-BUSINESS  DATE NOV 15 1964	
DATE NOV 15 1964		WMB & A. 1115-1	

2085-33-65-007

044 213 Cornell University B & I

110