





**ROBSON
&
WOESE INC.**

CONSULTING ENGINEERS



SYRACUSE, N.Y.
ROCHESTER, N.Y.

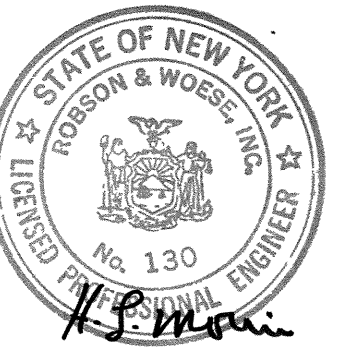


IT IS A VIOLATION OF THE NEW YORK STATE
EDUCATION LAW FOR ANY PERSON, UNLESS
HE IS ACTING UNDER THE DIRECTION OF A
LICENSED PROFESSIONAL ENGINEER, TO
ALTER AN ITEM ON THIS DOCUMENT IN ANY
WAY

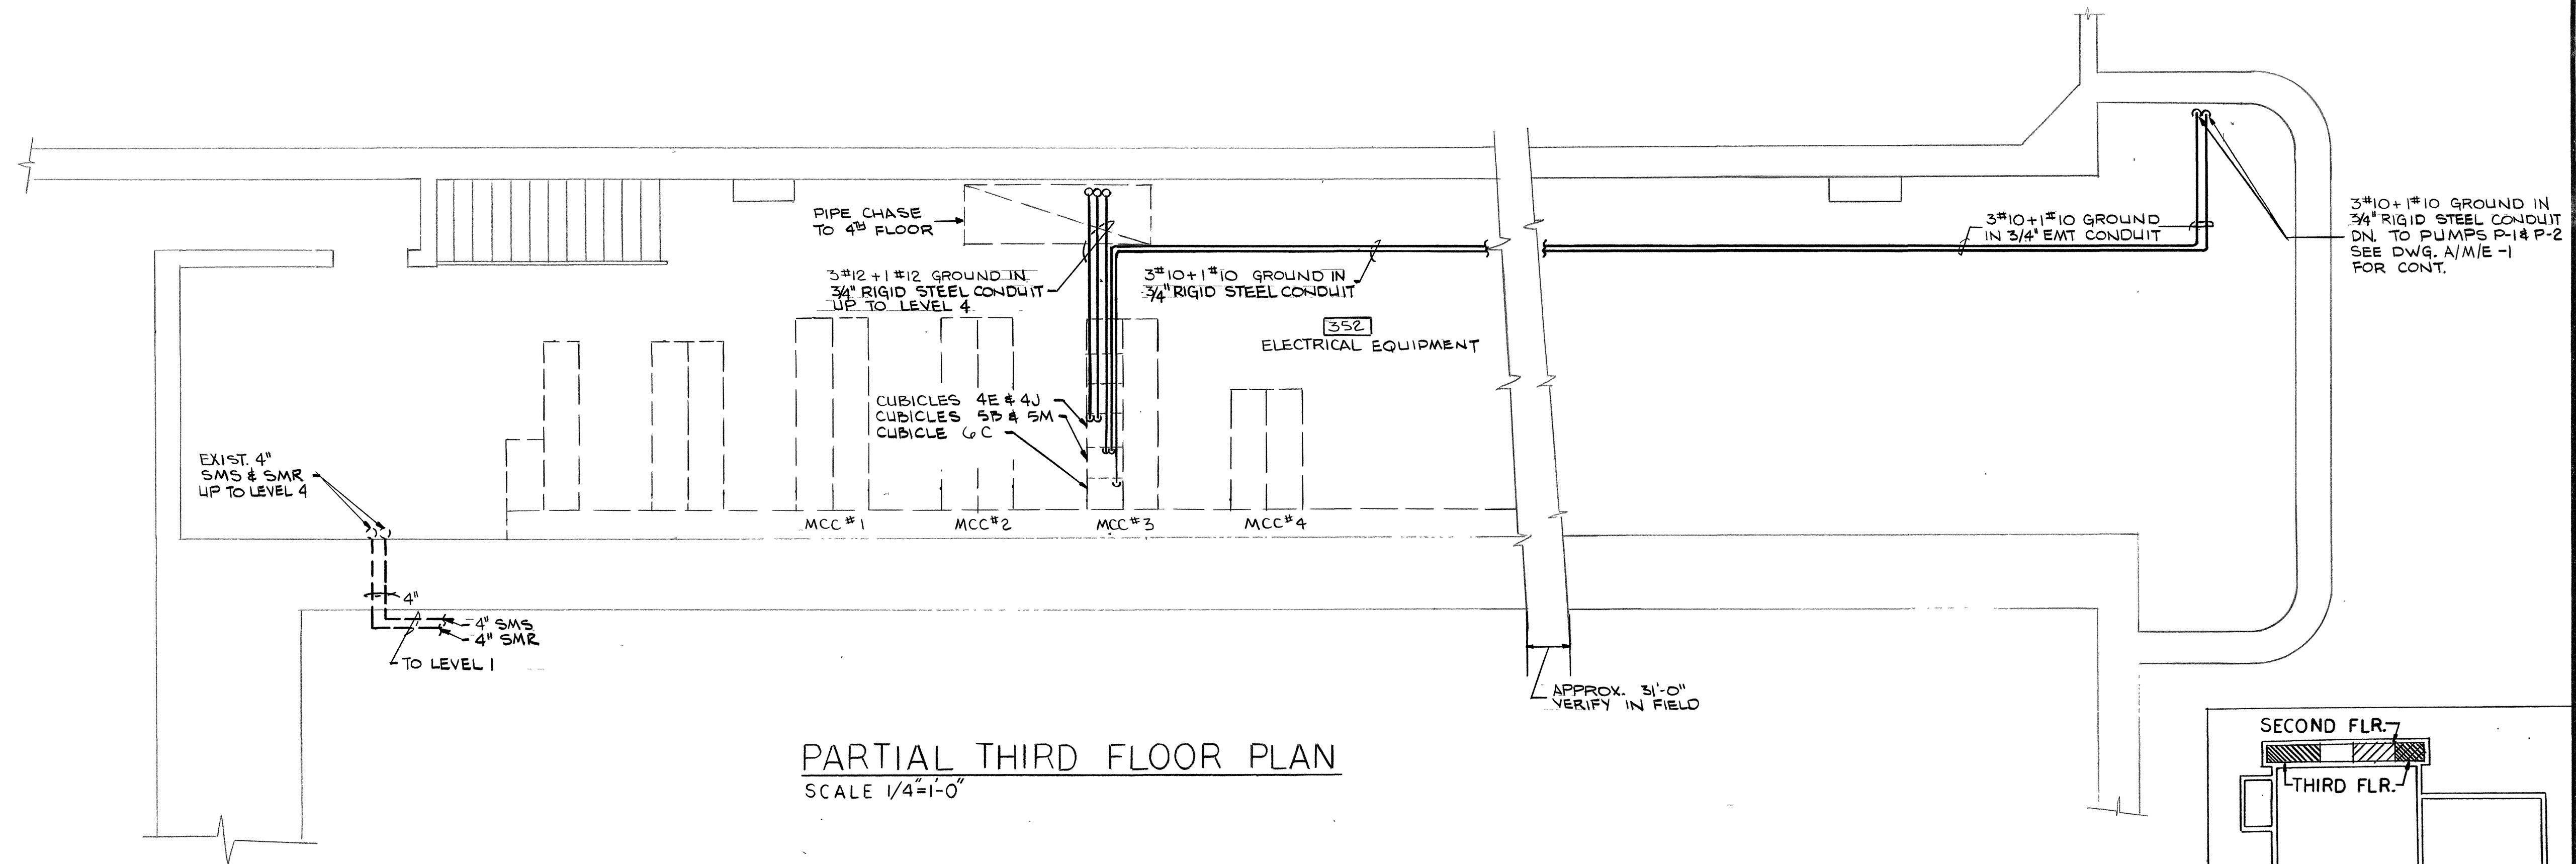

PARTIAL THIRD FLOOR PLAN
SCALE 1/4"=1'-0"

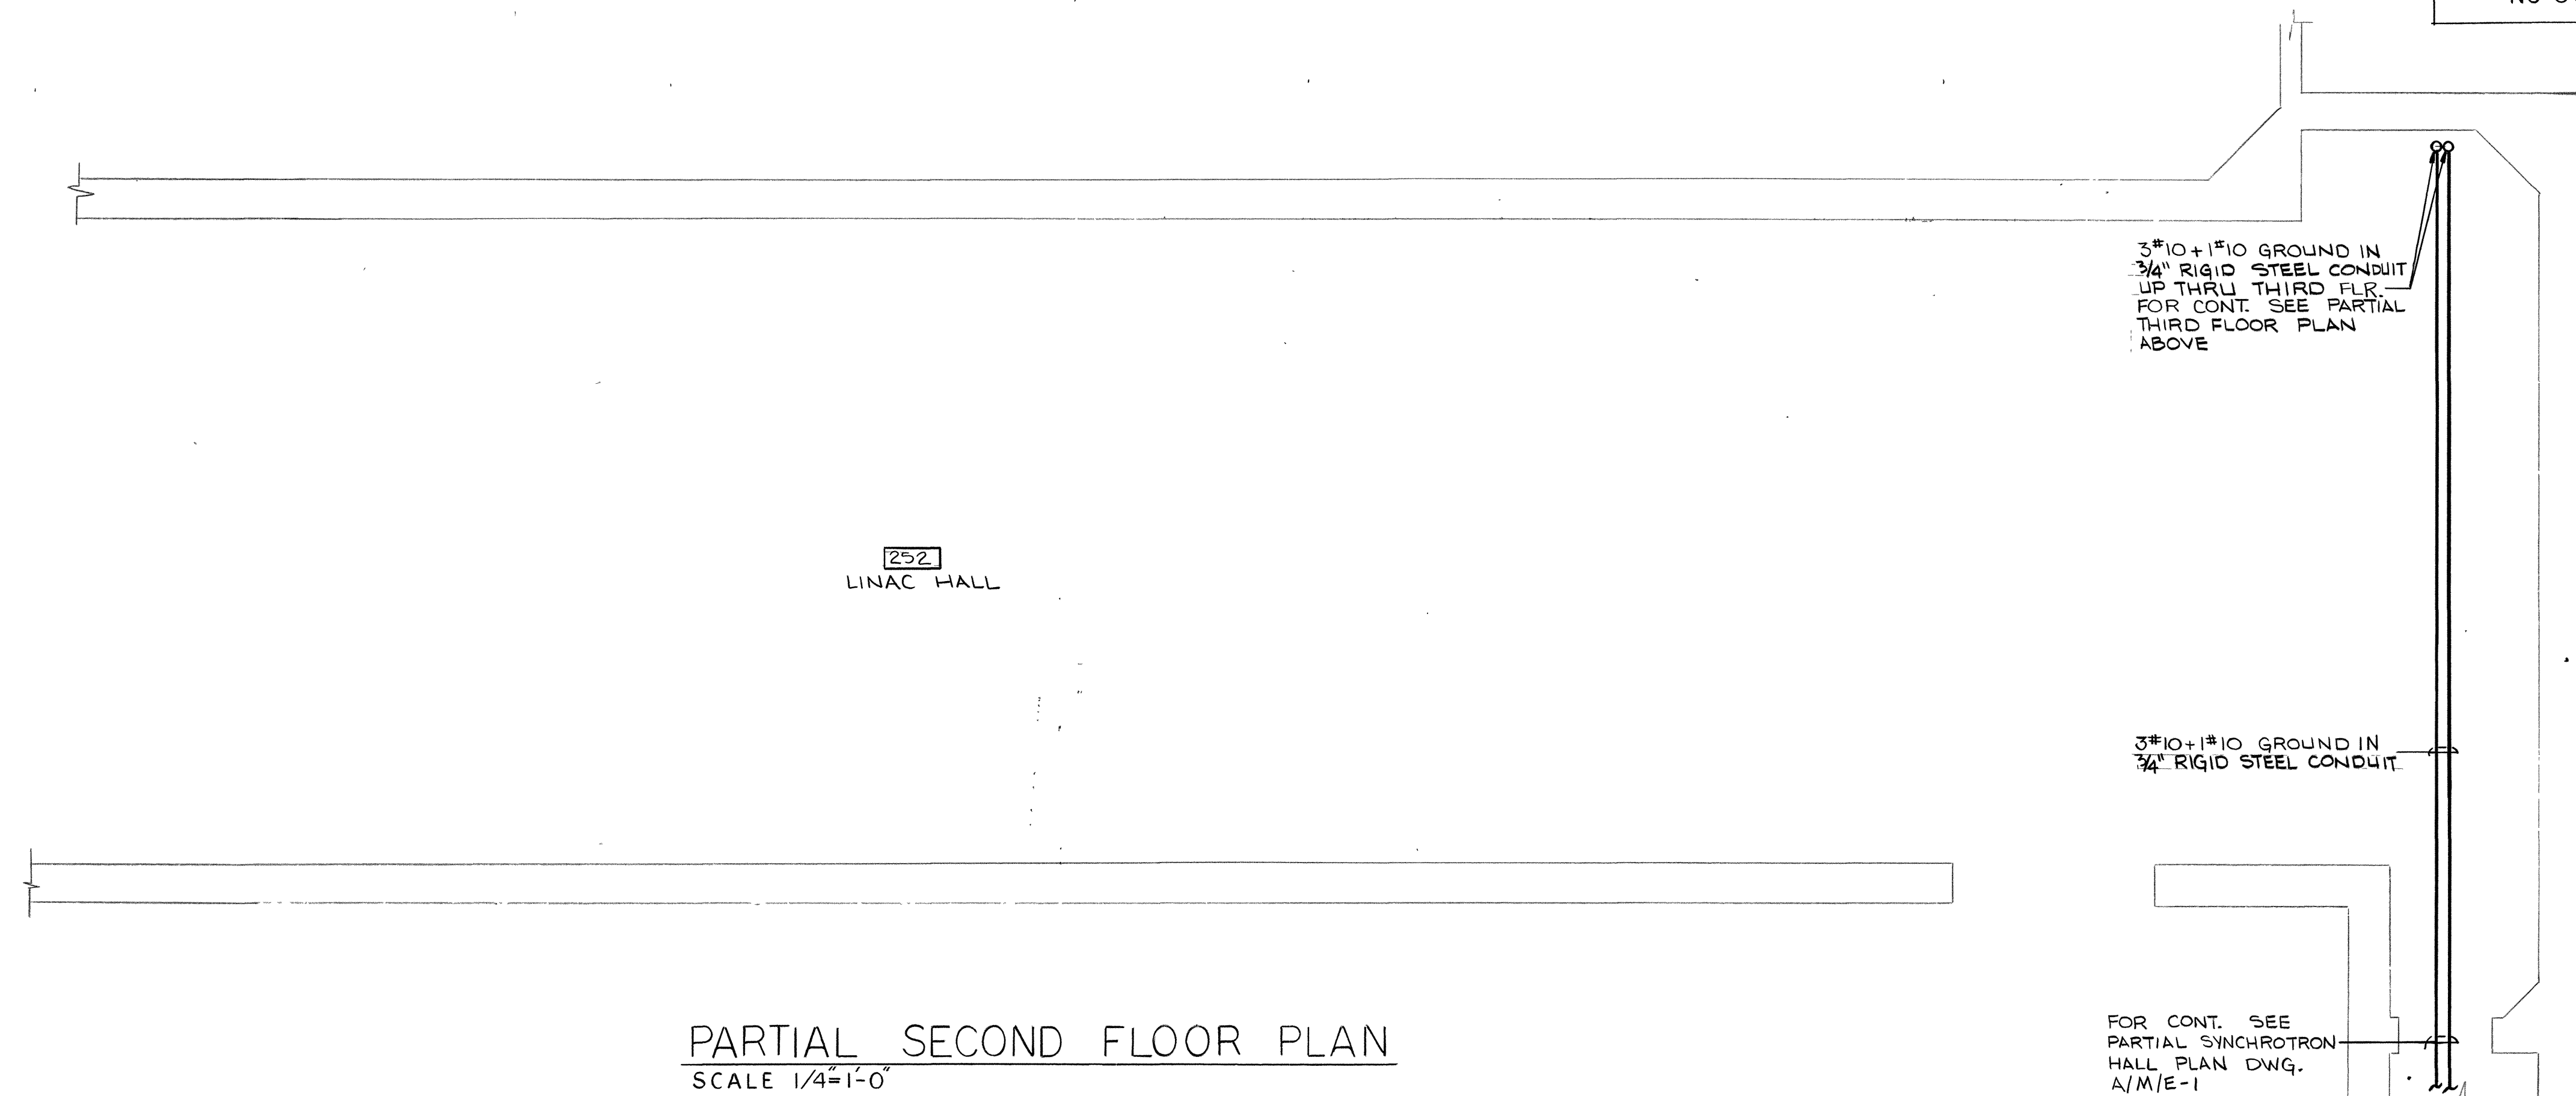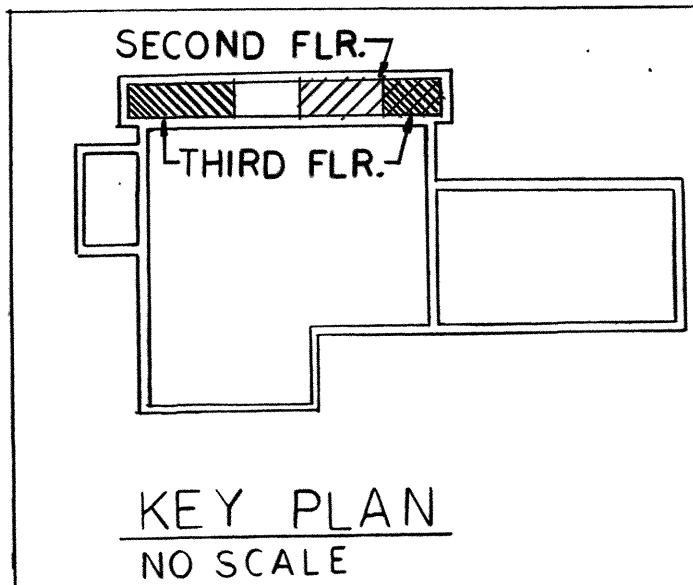

PARTIAL SECOND FLOOR PLAN
SCALE 1/4"=1'-0"

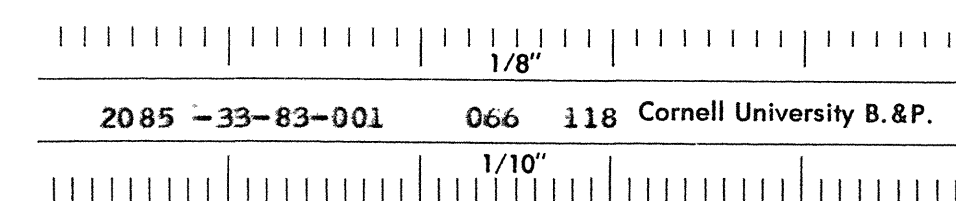

NO.	REVISIONS	DATE
JOB NO.	1 - 2155	
DRAWN BY	DRG	
CHECKED BY	RLL / TAD	
SCALE	As Shown	
DATE	April 1983	
DATE ISSUED		
PROJECT	WILSON LABORATORY	
CORNELL ITHACA	UNIVERSITY NEW YORK	
TITLE	HEAT RECOVERY & DOOR CURTAINS LEVELS 2 & 3	
DRAWING NO.	M/E-2	