




**ROBSON  
&  
WOESE INC.**

CONSULTING ENGINEERS


SYRACUSE, N.Y.  
ROCHESTER, N.Y.




IT IS A VIOLATION OF THE NEW YORK STATE  
EDUCATION LAW FOR ANY PERSON, UNLESS  
HE IS ACTING UNDER THE DIRECTION OF A  
LICENSED PROFESSIONAL ENGINEER, TO  
ALTER AN ITEM ON THIS DOCUMENT IN ANY  
WAY

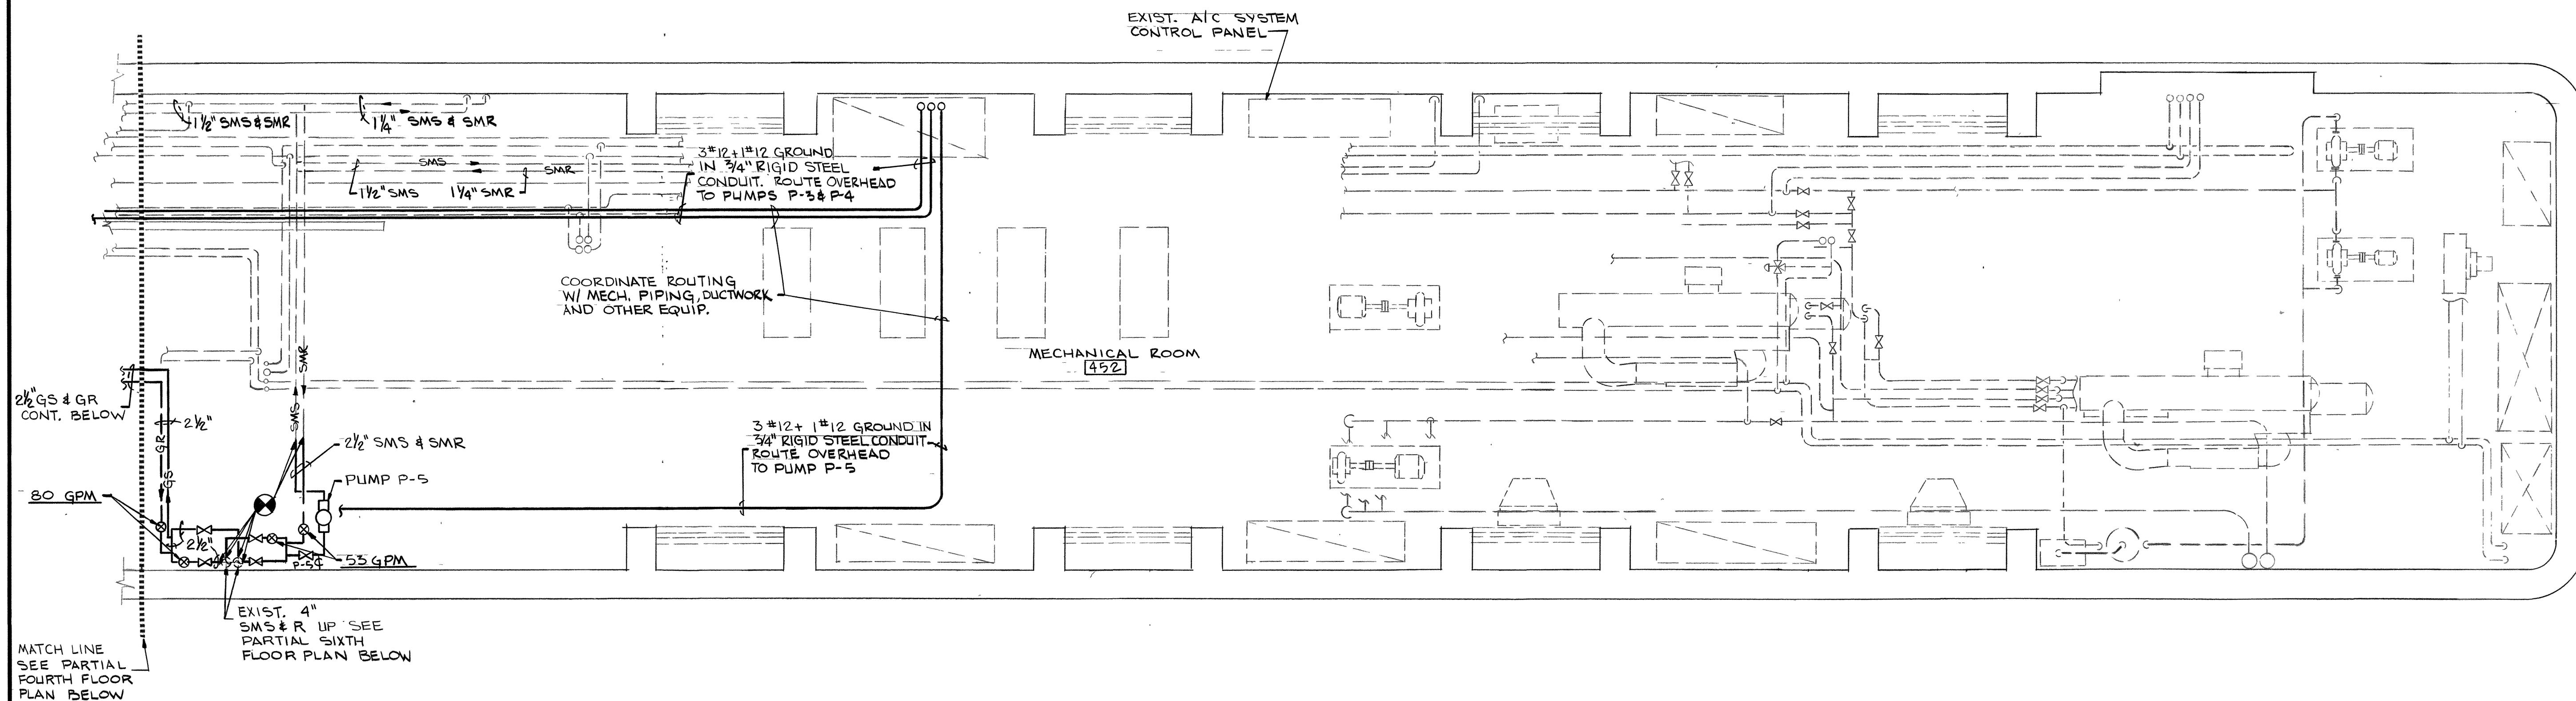

PARTIAL FOURTH FLOOR PLAN  
SCALE 1/4"=1'-0"

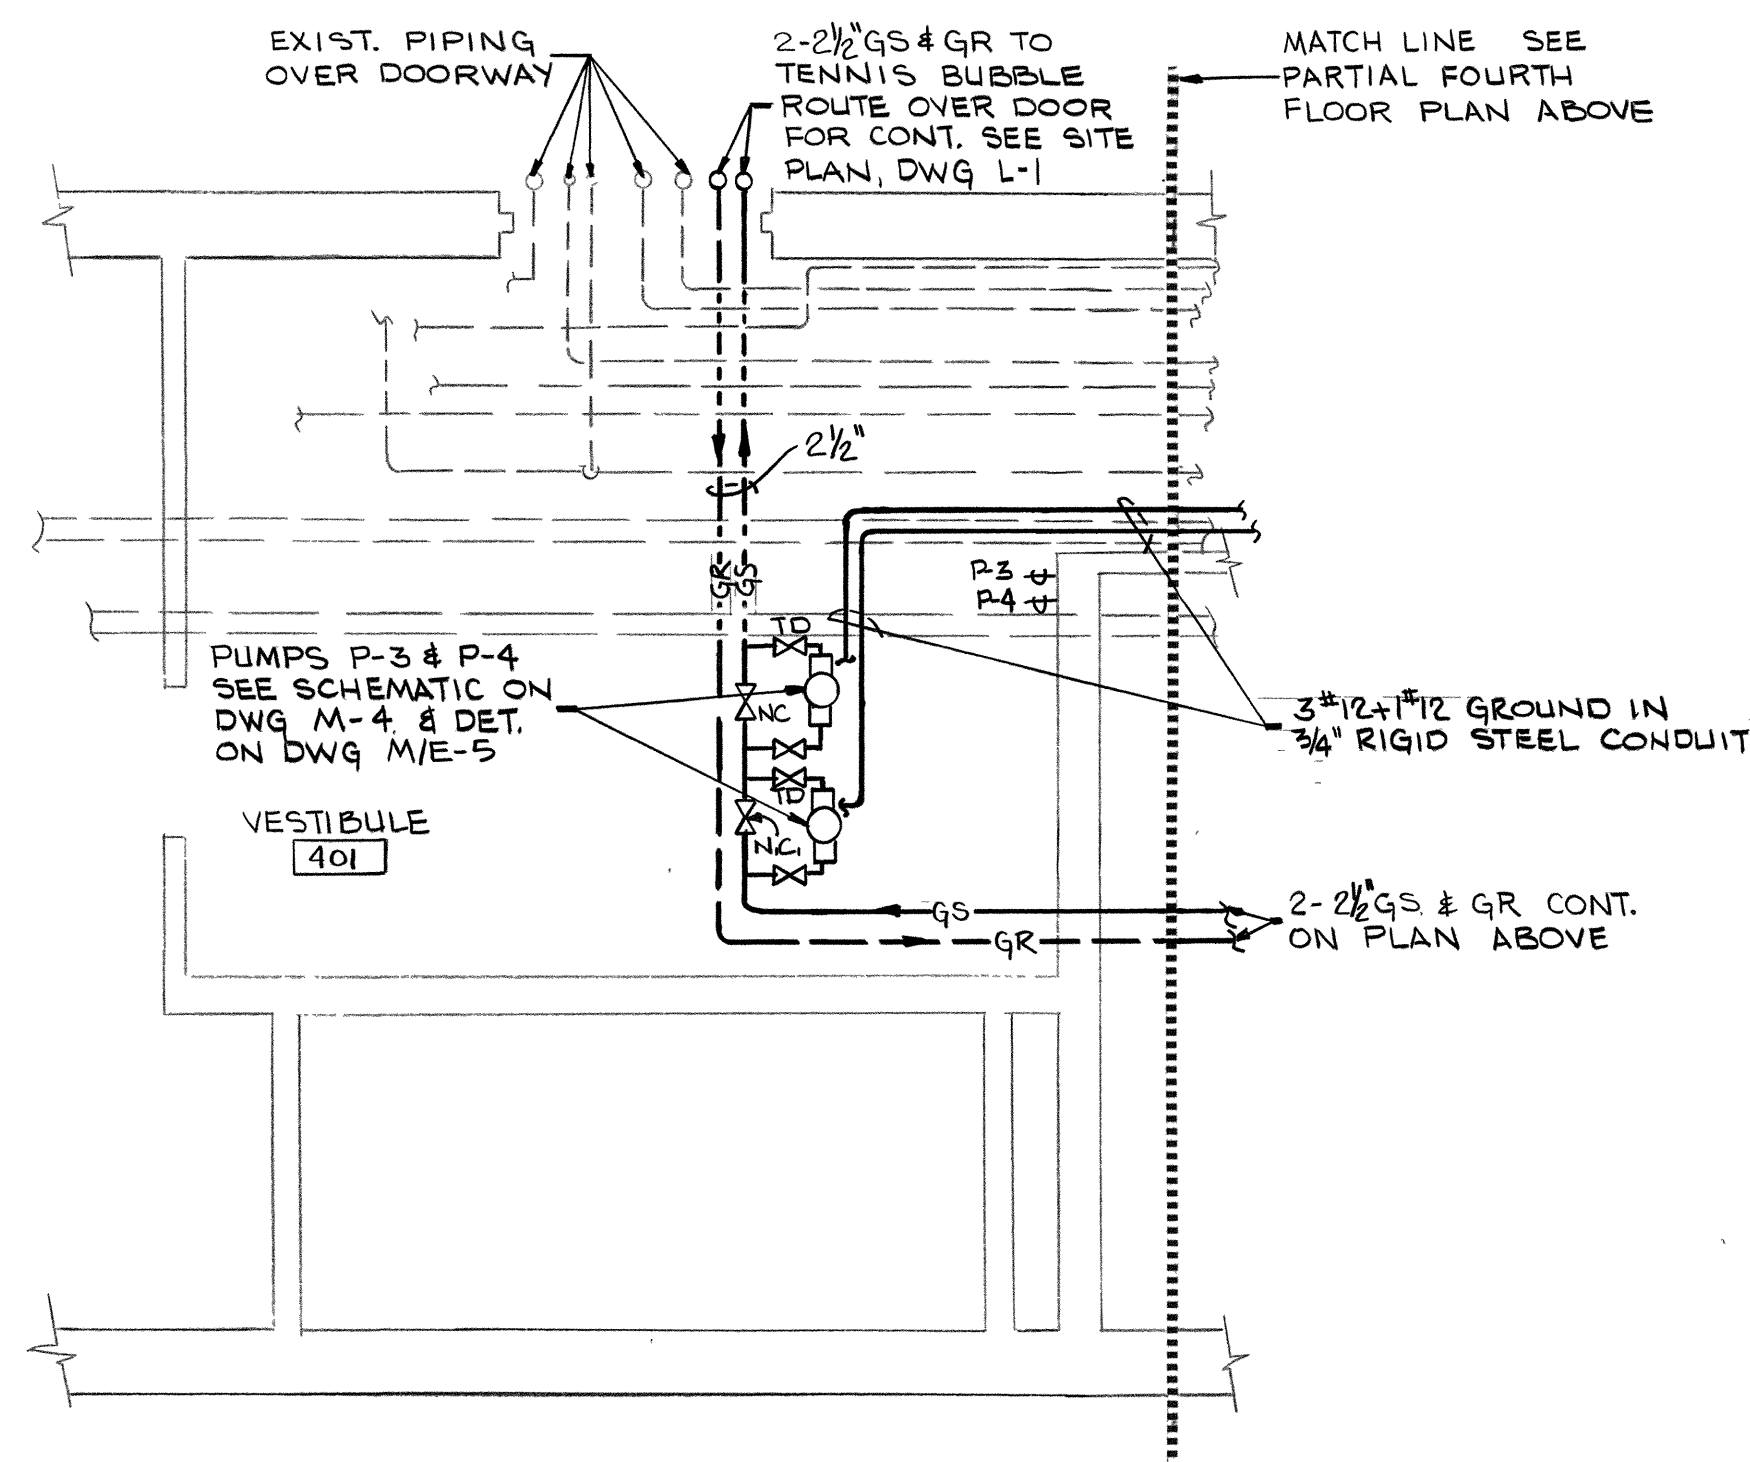


PARTIAL FOURTH FLOOR PLAN  
SCALE 1/4"=1'-0"

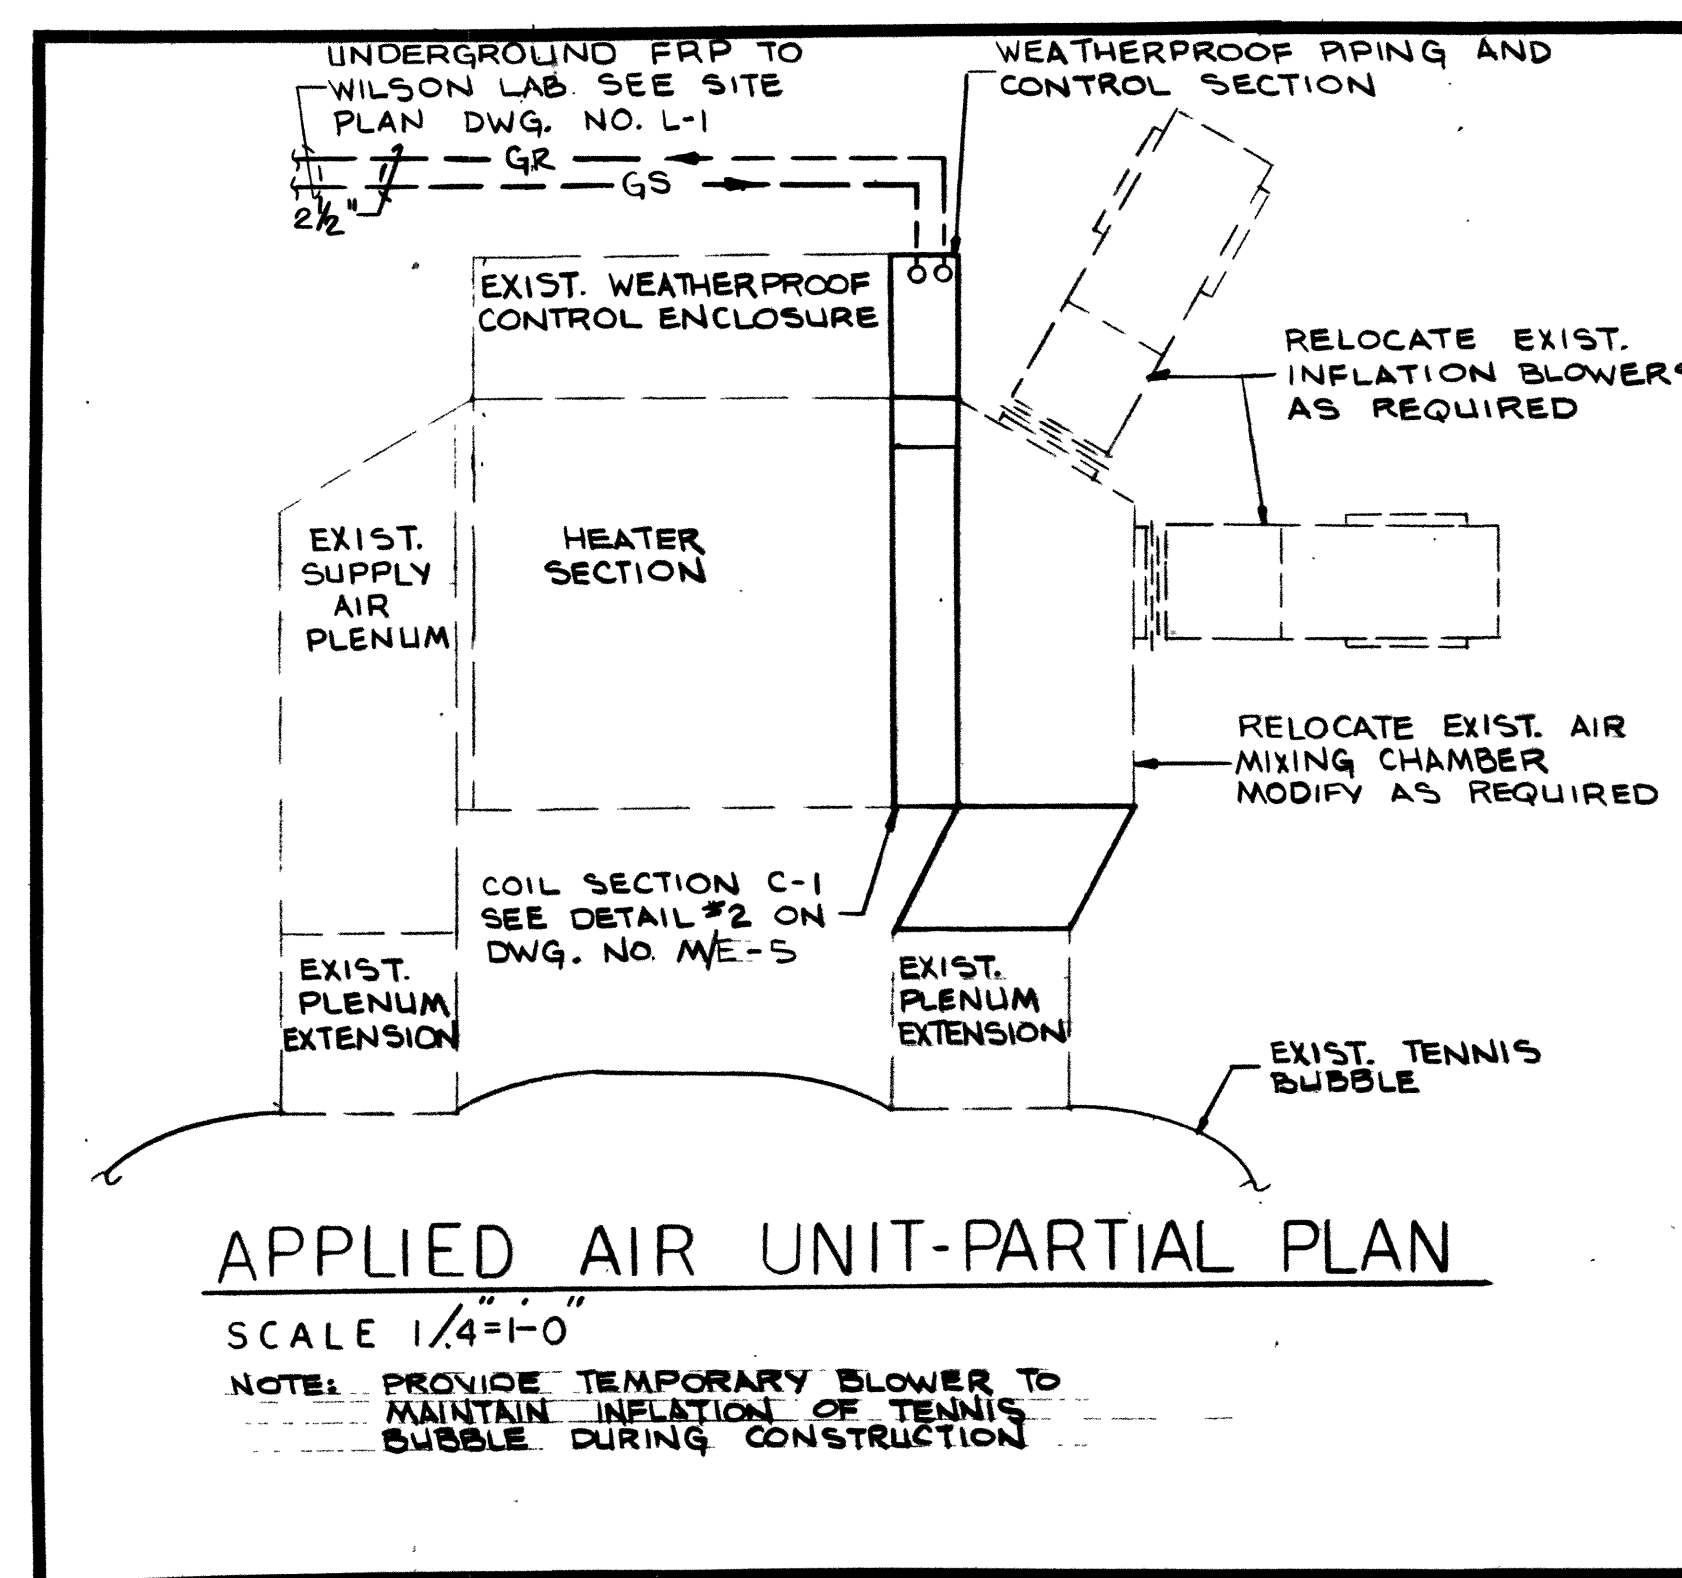

APPLIED AIR UNIT-PARTIAL PLAN

SCALE 1/4"=1'-0"

NOTE: PROVIDE TEMPORARY BLOWER TO  
MAINTAIN INFLATION OF TENNIS  
BUBBLE DURING CONSTRUCTION

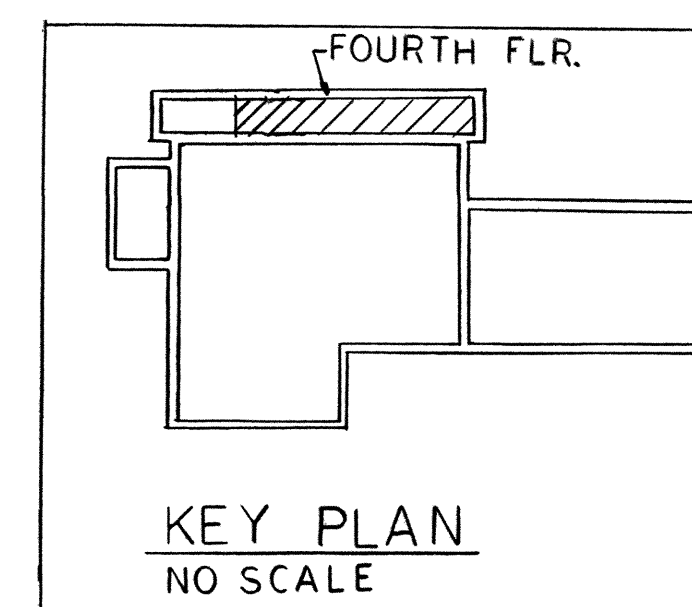

2085 -33-83-001 066 119 Cornell University B.&P.  
1/10"



| NO.         | REVISIONS  | DATE |
|-------------|------------|------|
| JOB NO.     | 1 - 2155   |      |
| DRAWN BY    | DRG        |      |
| CHECKED BY  | RLL / TAD  |      |
| SCALE       | As Shown   |      |
| DATE        | April 1983 |      |
| DATE ISSUED |            |      |

PROJECT  
WILSON  
LABORATORY  
CORNELL  
ITHACA UNIVERSITY  
NEW YORK

TITLE  
HEAT  
RECOVERY  
&  
DOOR CURTAINS  
LEVEL 4

DRAWING NO.  
**M/E-3**