




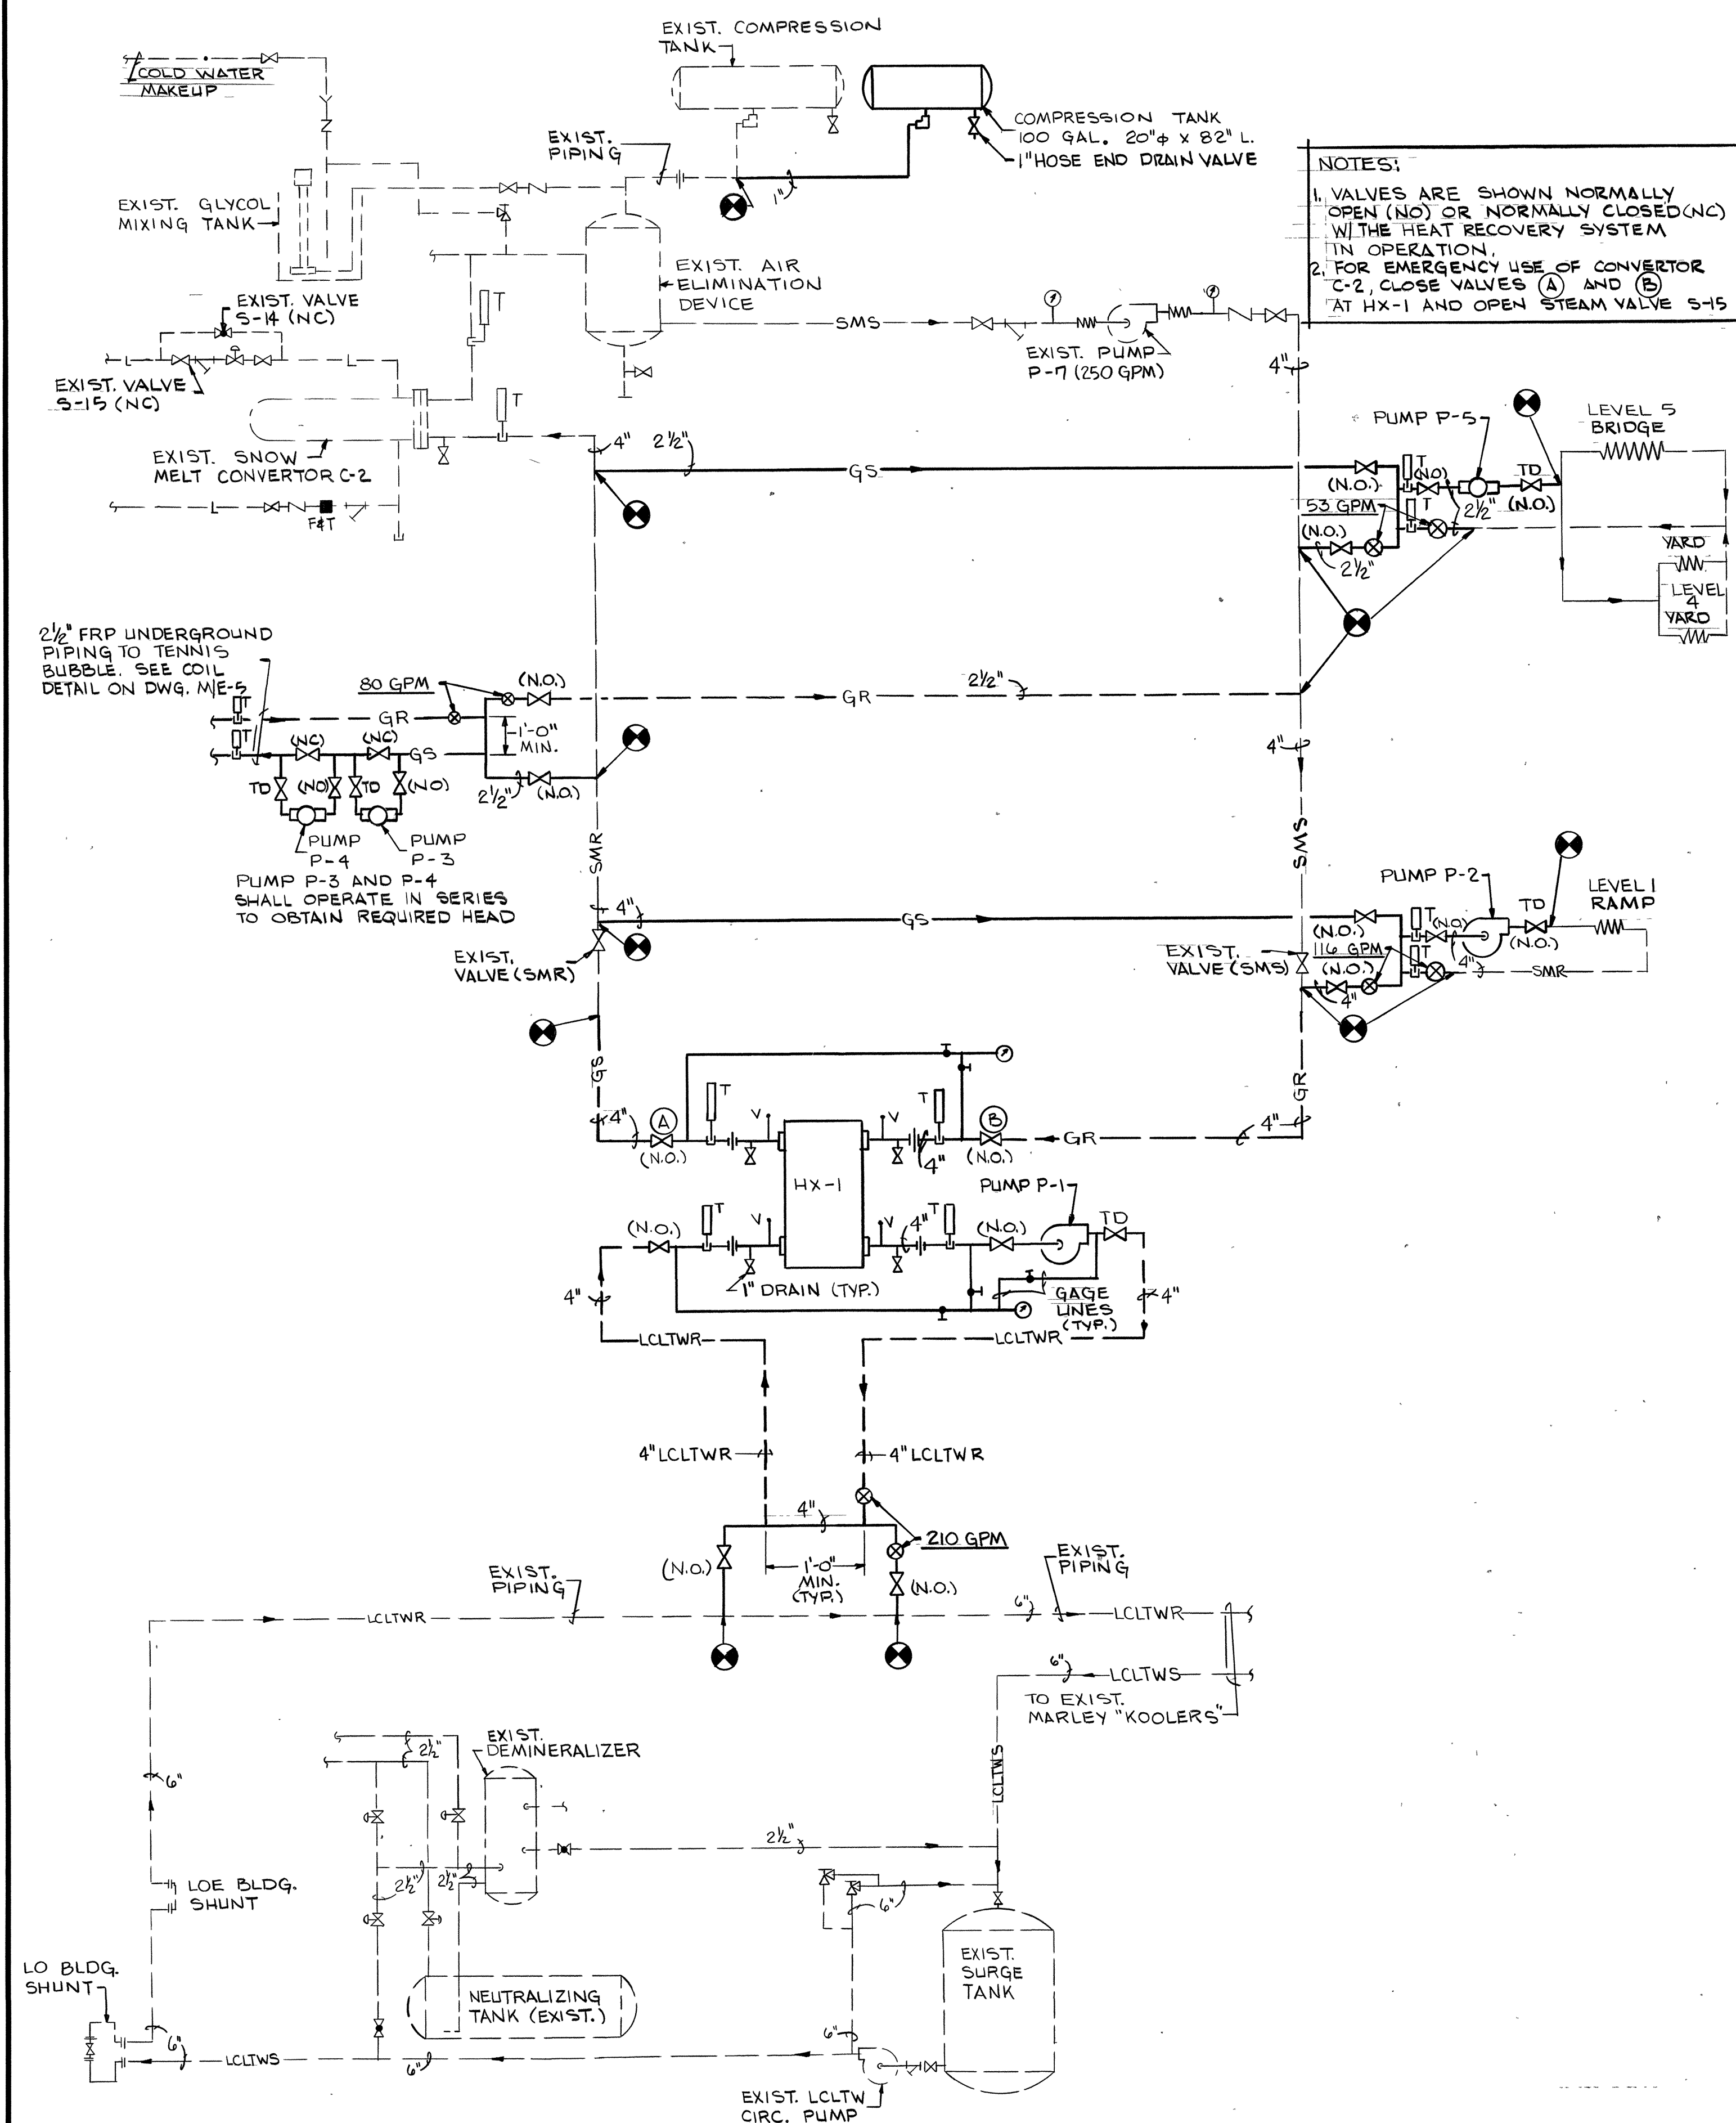


LCLTW HEAT RECOVERY PIPING SCHEMATIC
NO SCALE

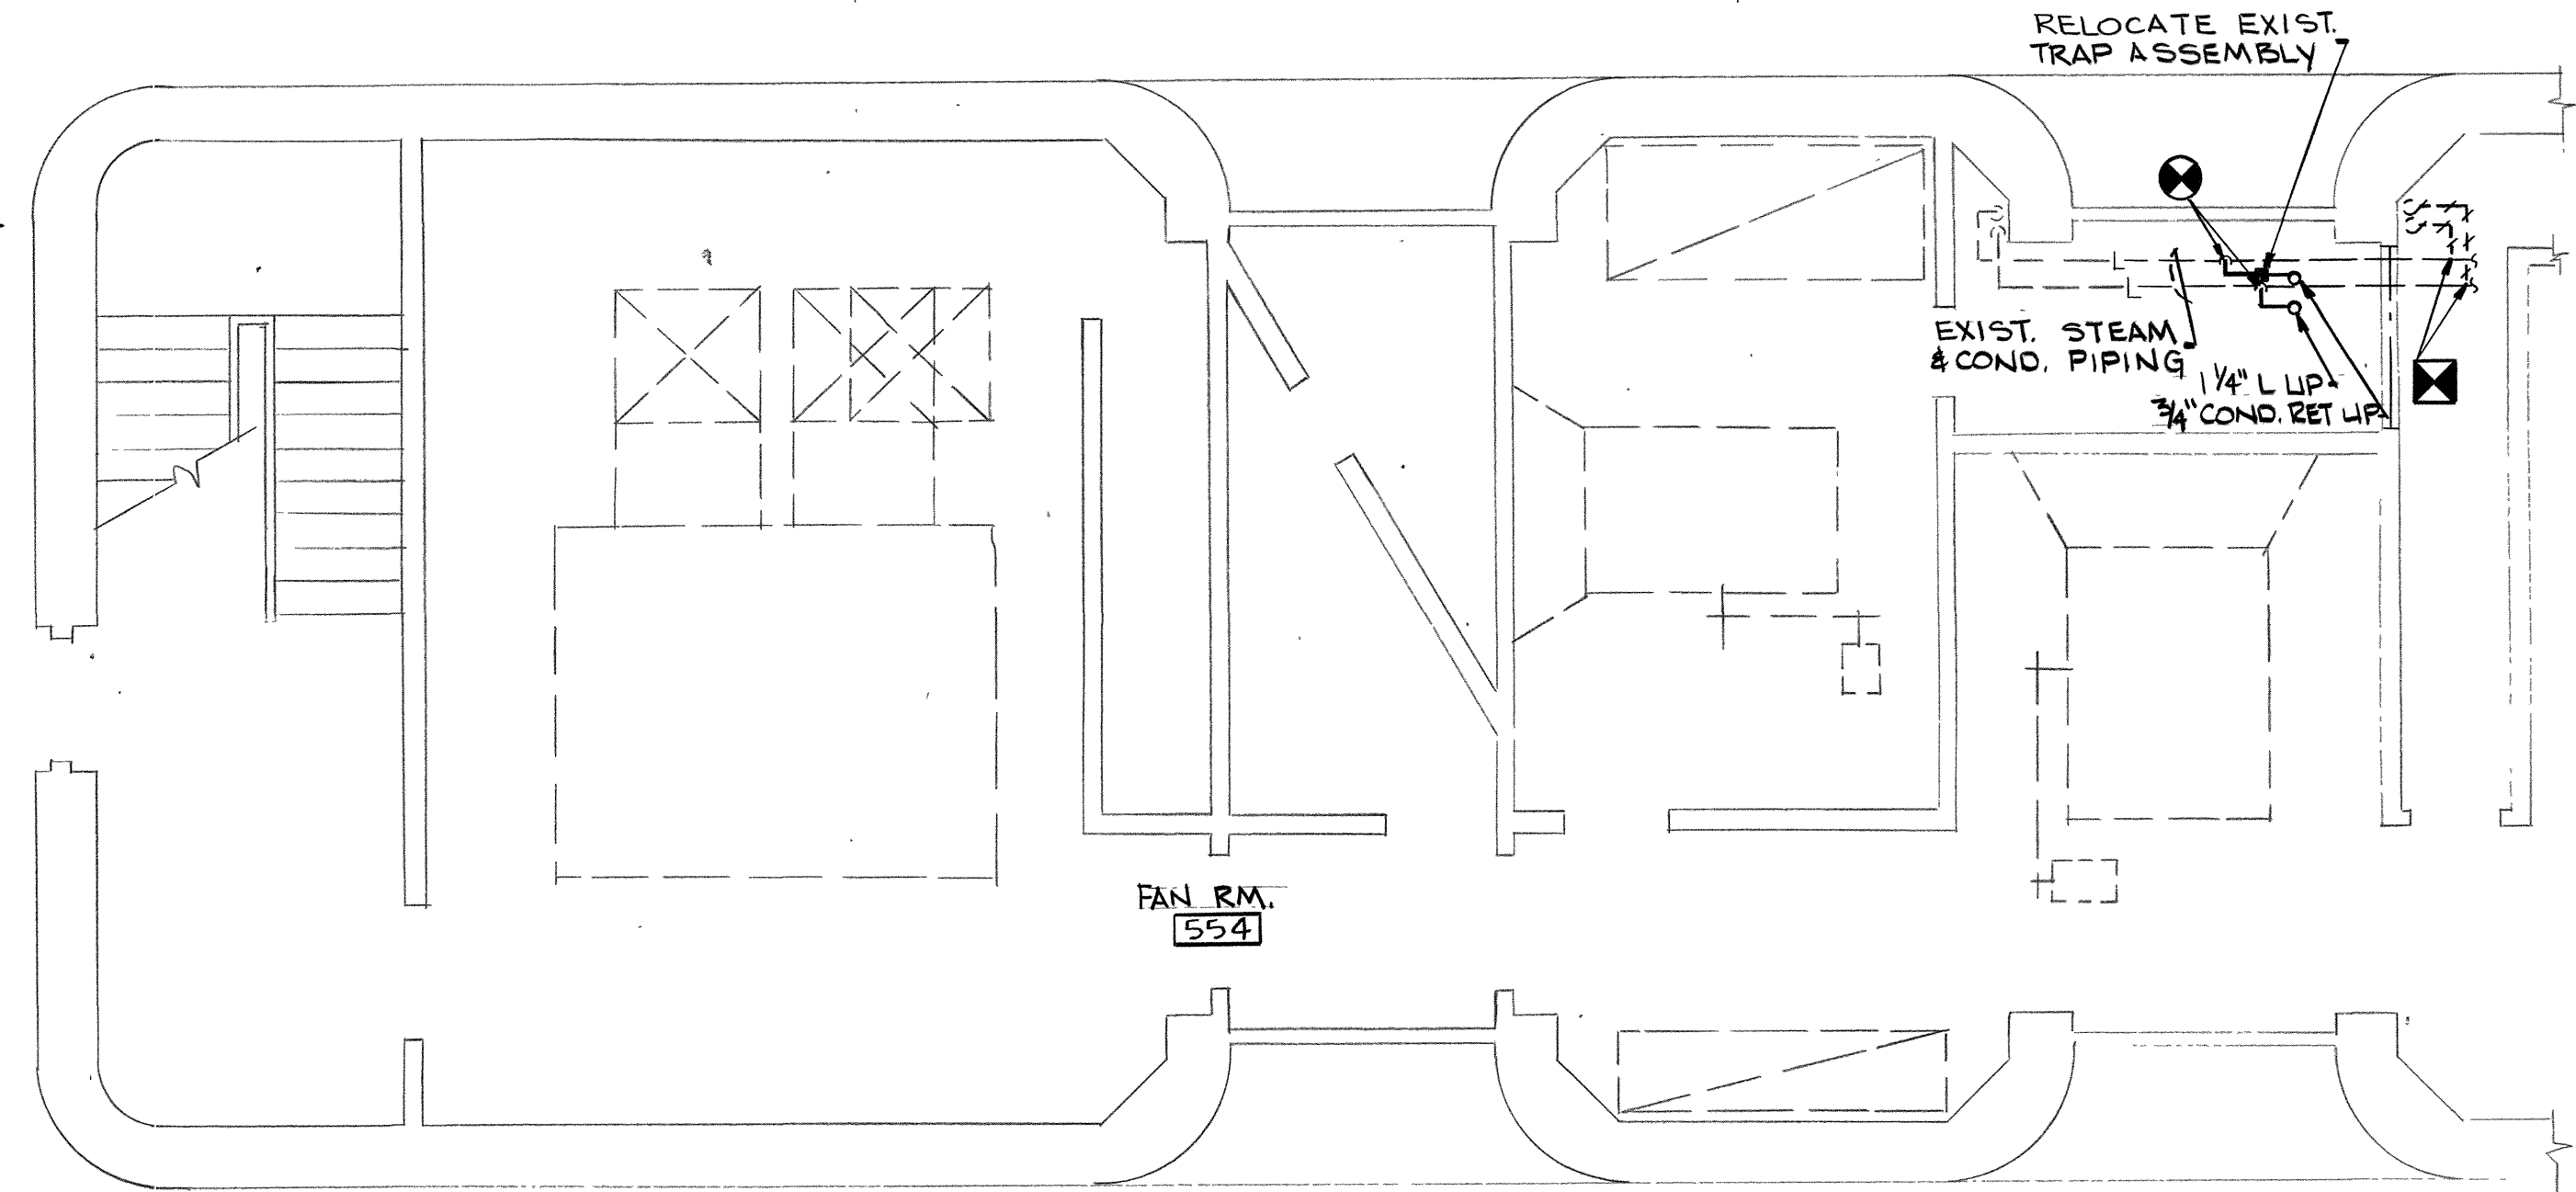


PARTIAL FIFTH FLOOR PLAN
SCALE 1/4"=1'-0"

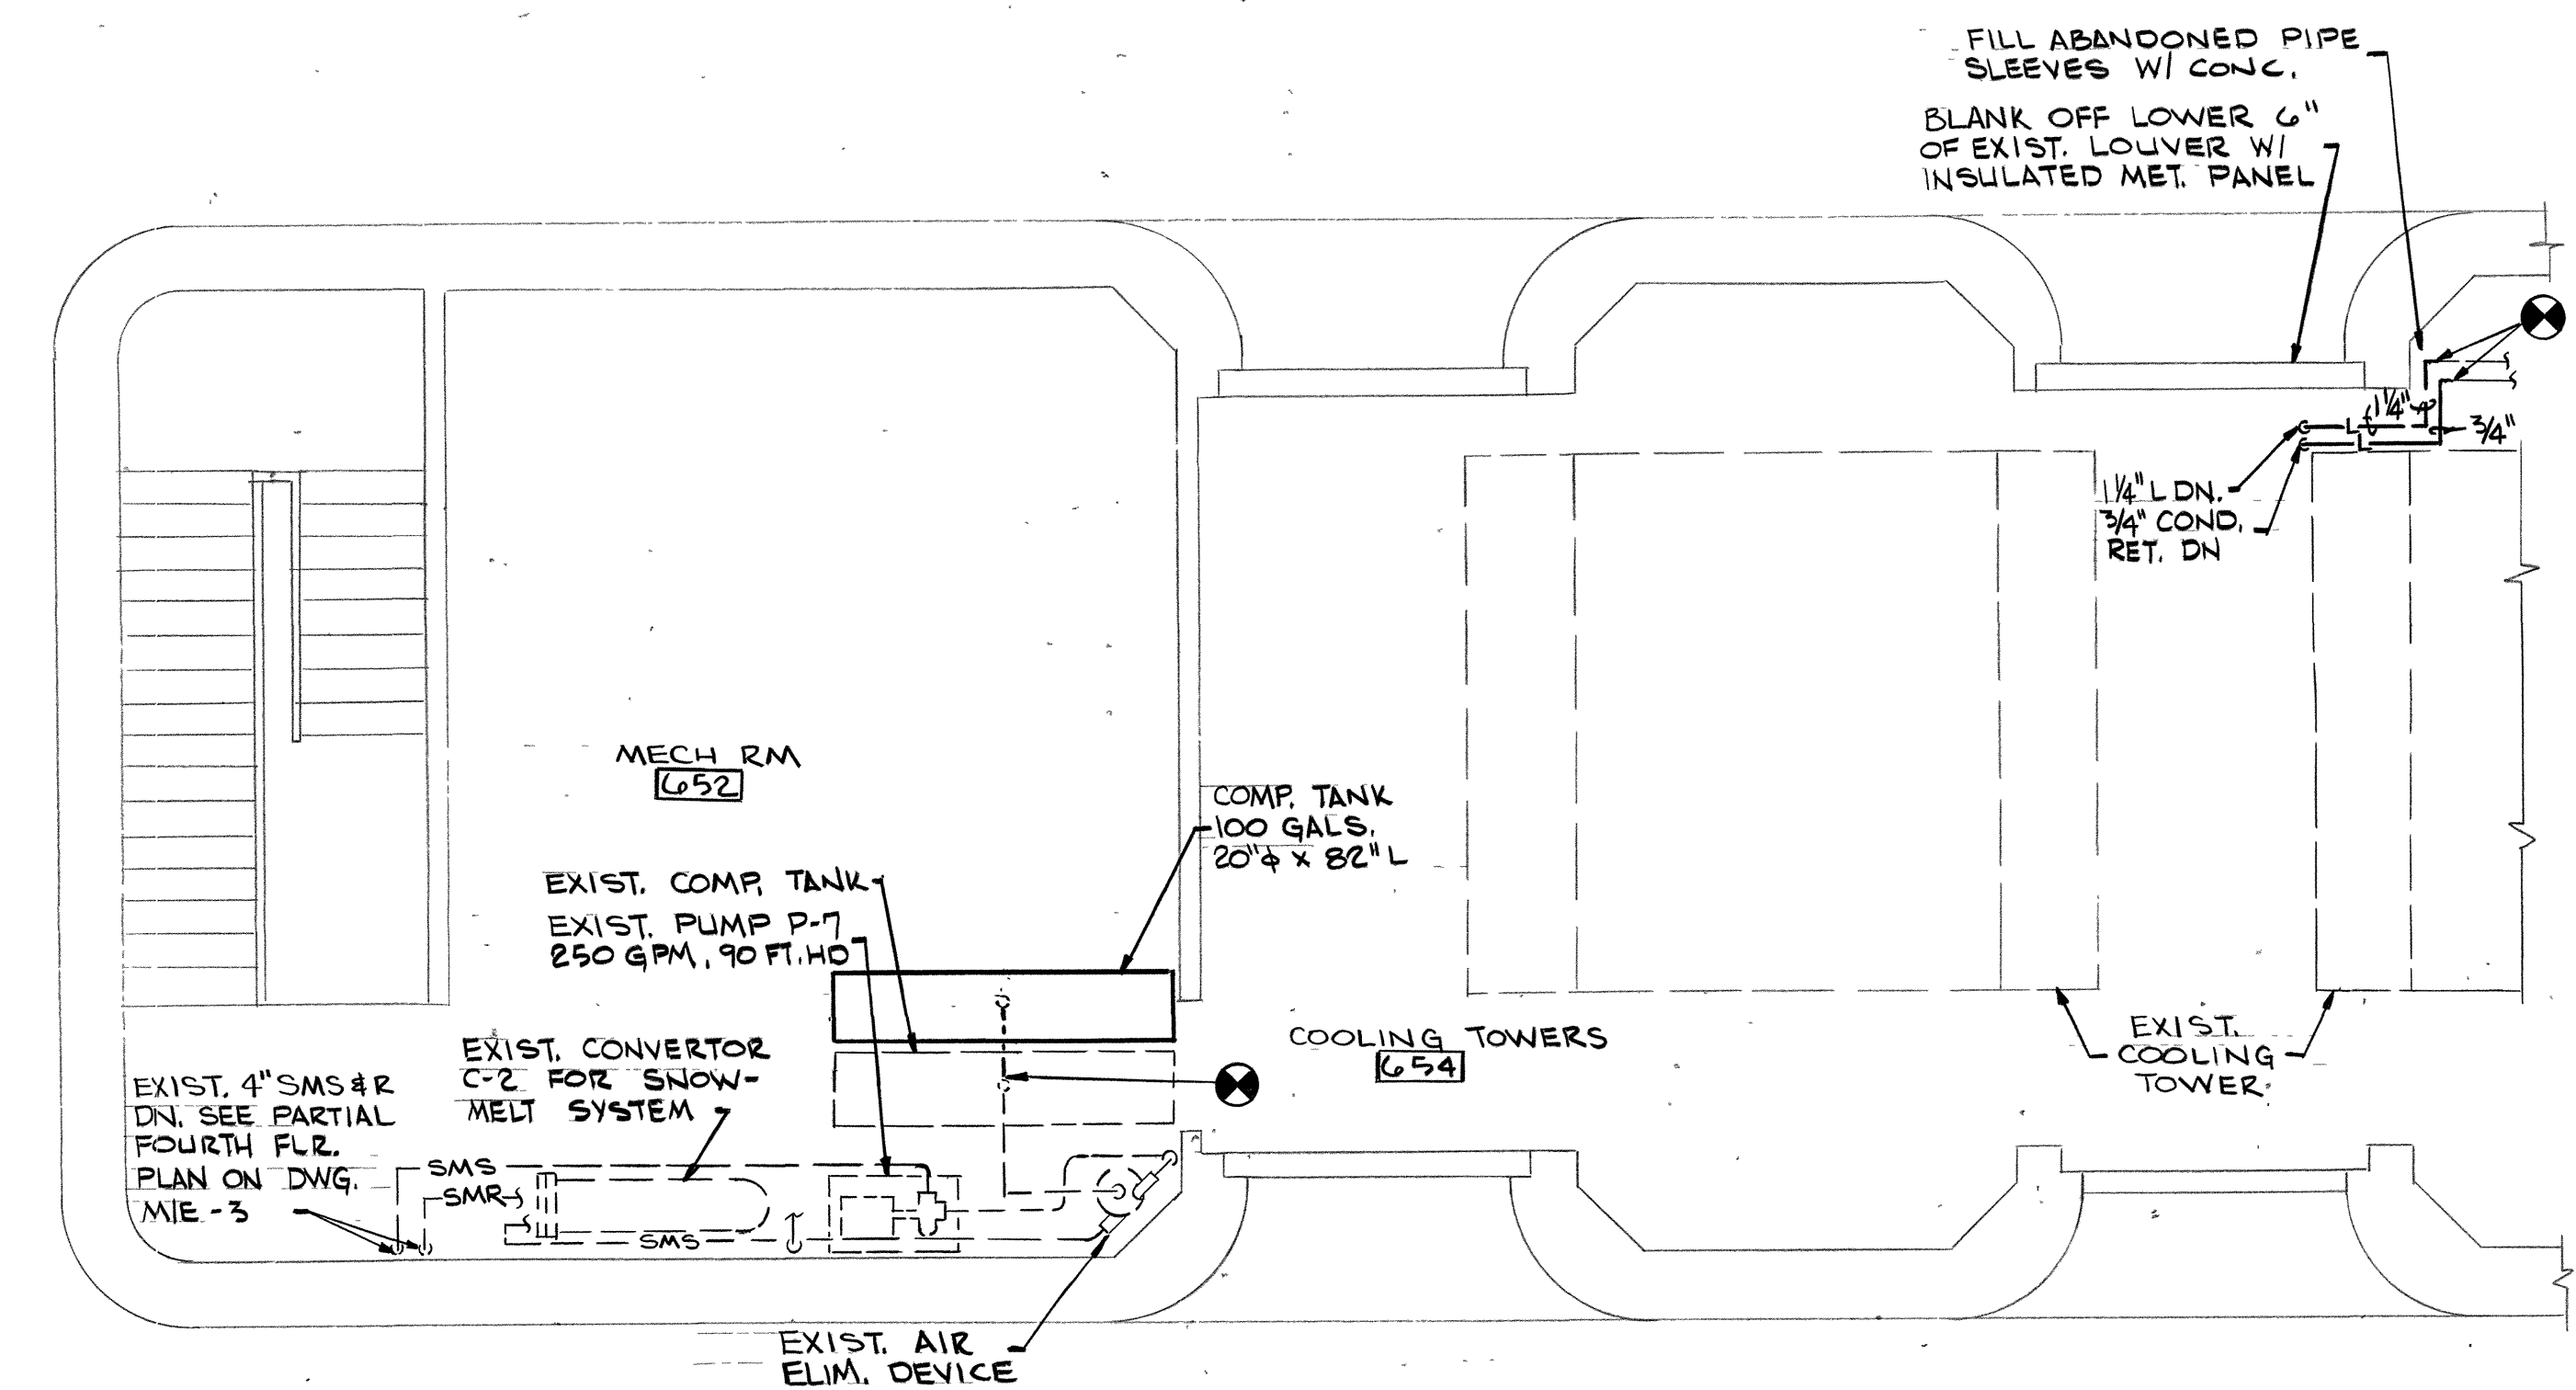

PARTIAL SIXTH FLOOR PLAN
SCALE 1/4"=1'-0"

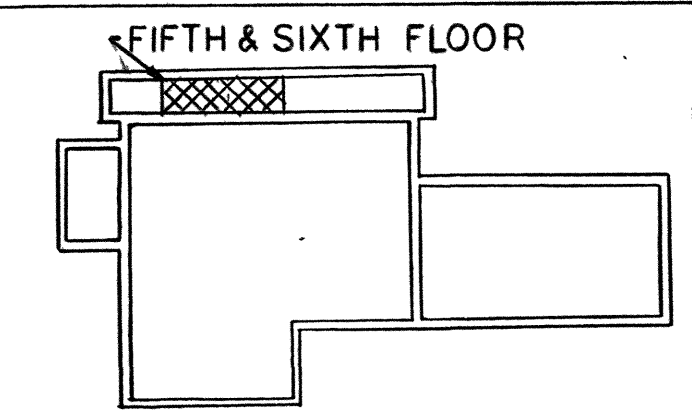

KEY PLAN
NO SCALE

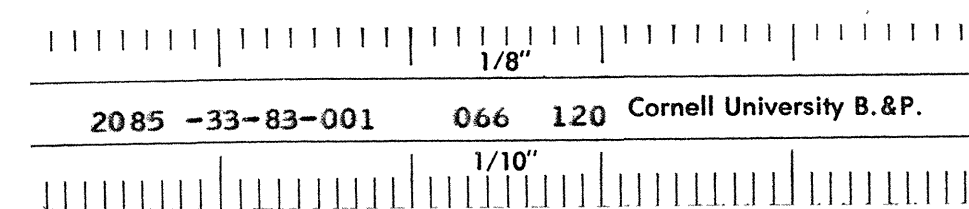

NO.	REVISIONS	DATE
JOB NO.	1 - 2155	
DRAWN BY	DRG	
CHECKED BY	RLL / TAD	
SCALE	As Shown	
DATE	April 1983	
DATE ISSUED		
PROJECT		
WILSON LABORATORY		
CORNELL THACCA	UNIVERSITY NEW YORK	
TITLE		
HEAT RECOVERY & DOOR CURTAINS LEVELS 5 & 6		
DRAWING NO.		
M - 4		