


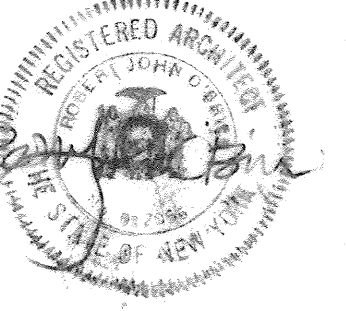

Addition to Wilson Laboratory
Cornell High Energy Synchrotron Source and Laboratory for Nuclear Studies
Cornell University, Ithaca, New York


Scale: As Noted	Date: 9 Nov 1984
Project No: 183054	Drawn by: GNC RB

Reflected Ceiling Plan
Level 1 Existing

A7

MATERIAL SYMBOLS

- EXISTING SUSPENDED ACOUSTIC CEILING BOARD
- SUSPENDED ACOUSTIC CEILING BOARD
- ACOUSTIC CEILING TILE
- GYPSUM BOARD
- FLUORESCENT LIGHT FIXTURE
- DIFFUSER
- RETURN AIR GRILLE
- RECESSED CAN LIGHT FIXTURE
- FUME HOOD VENT
- EGGCRATE LOUVER
- EXIT SIGN
- FLUORESCENT LIGHT W/ EGGCRATE LOUVER

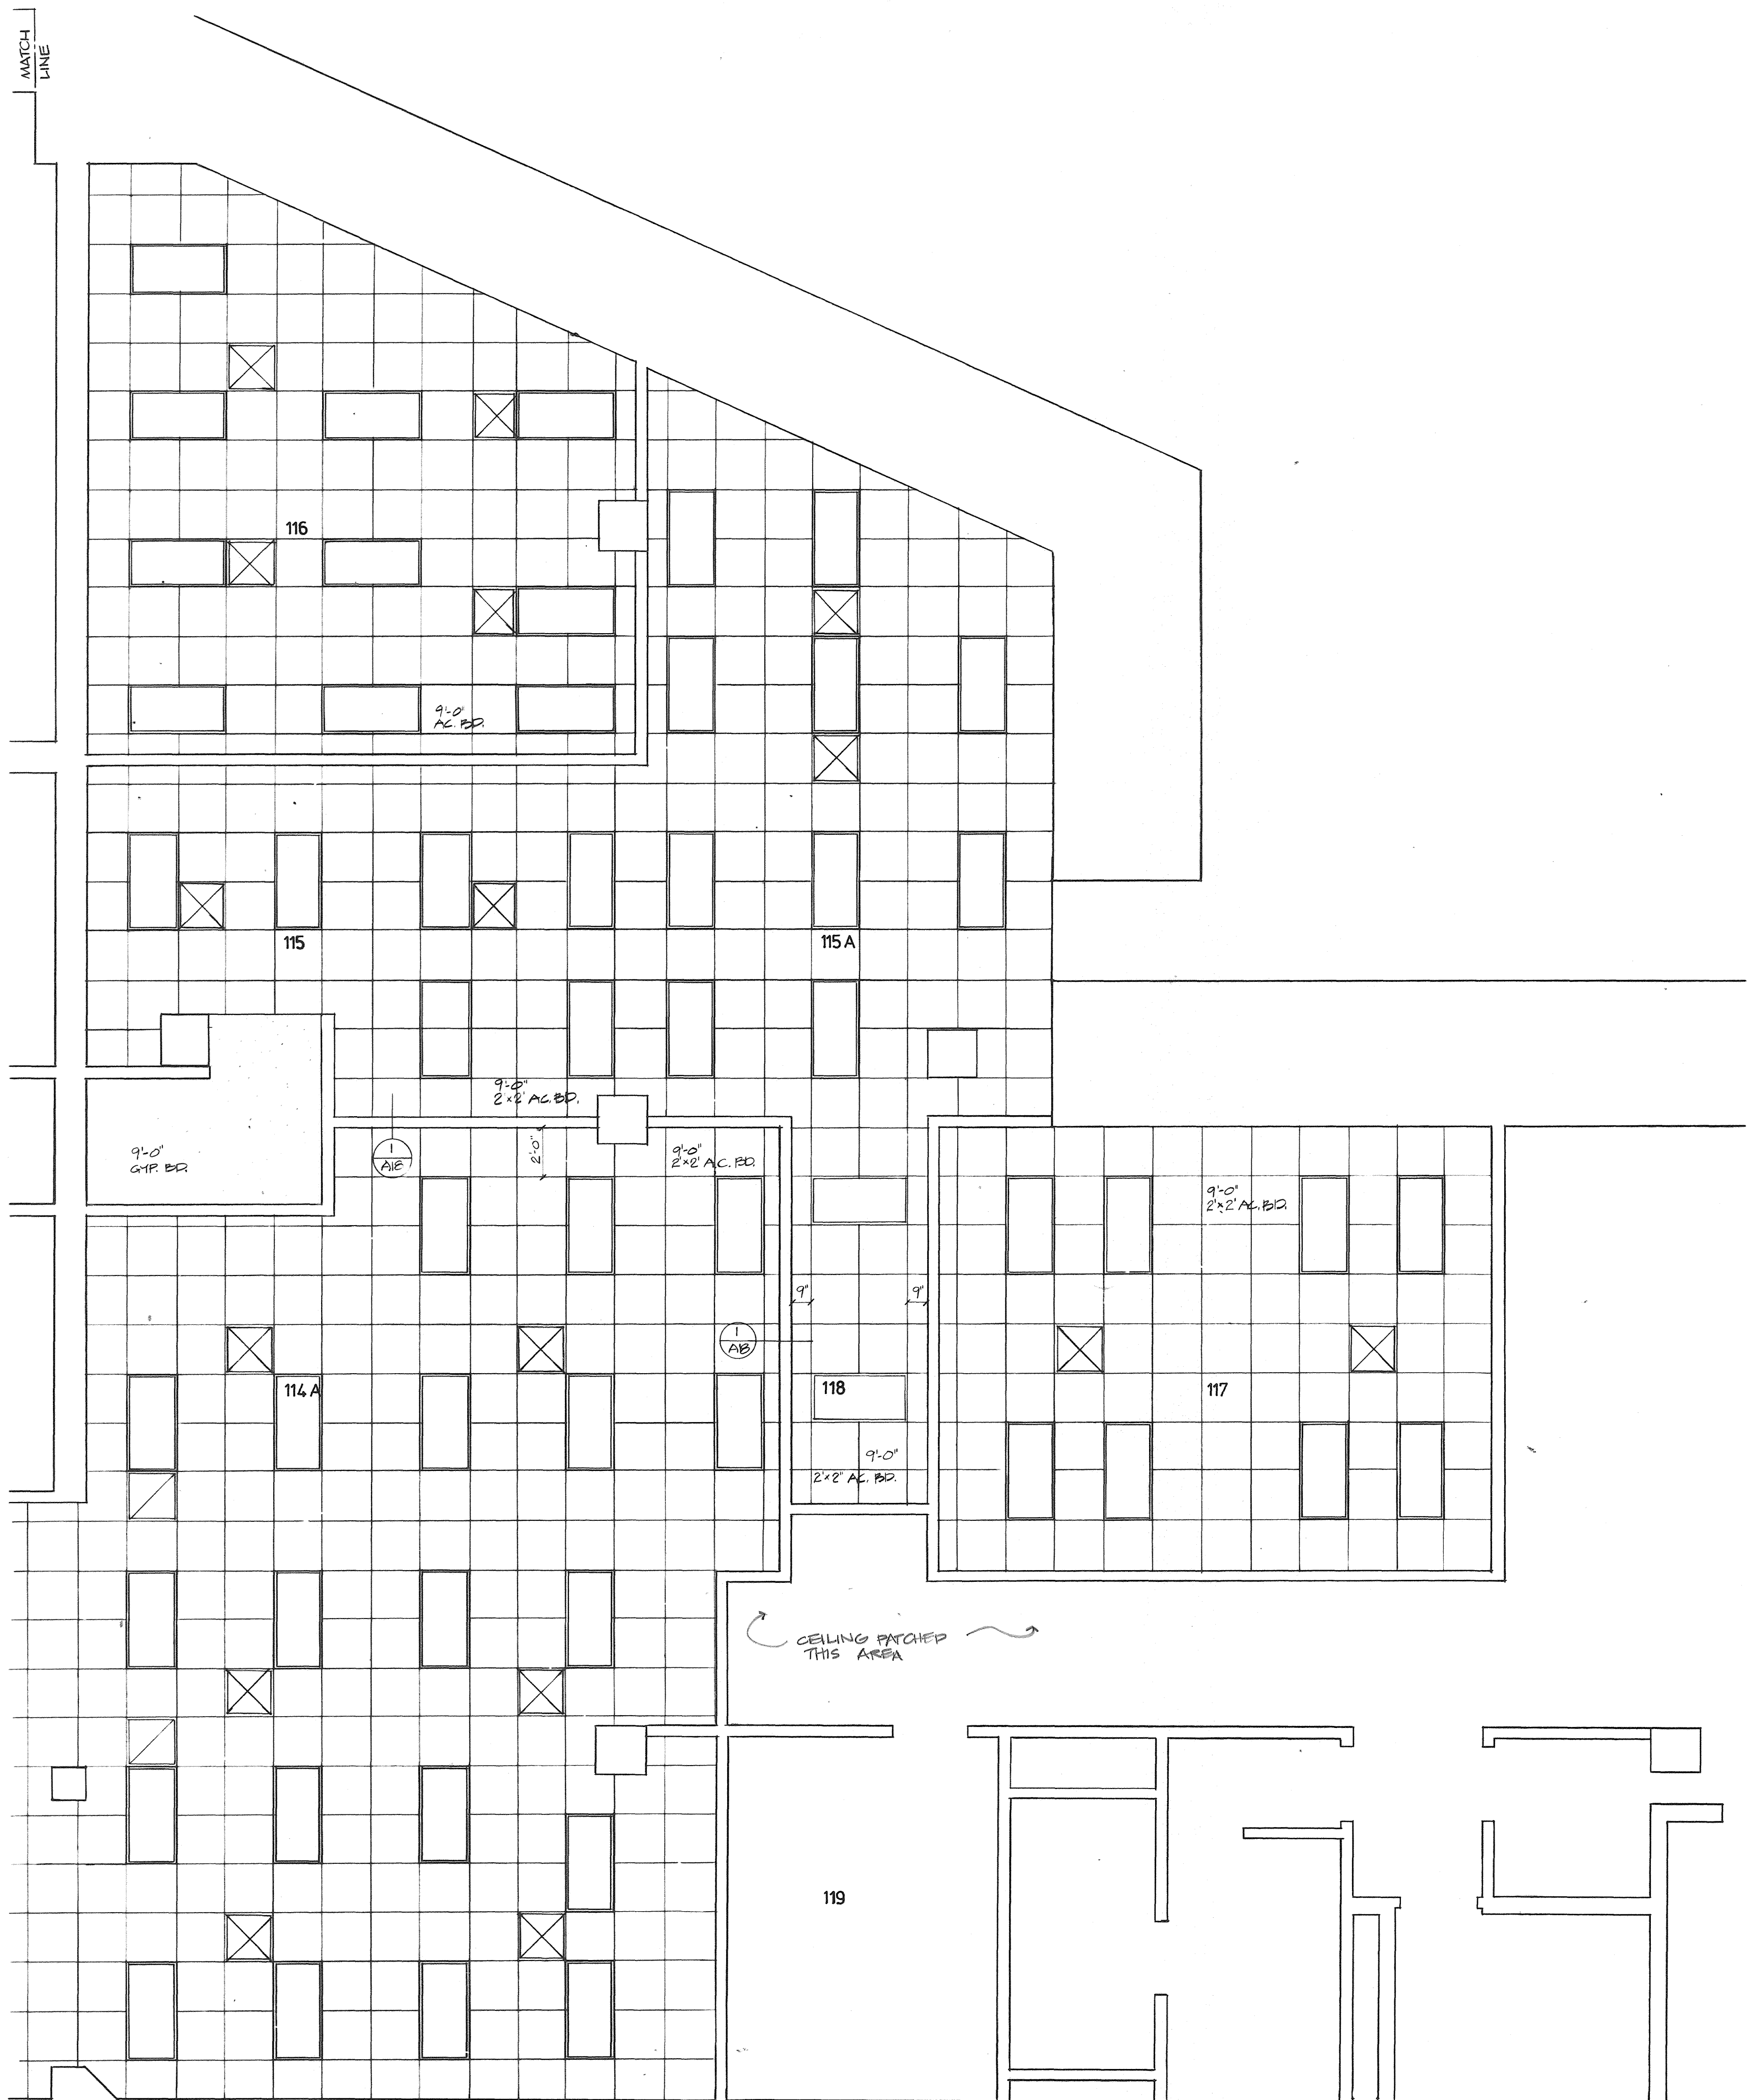

1 LEVEL ONE, EXISTING- REFLECTED CEILING PLAN
1/4" = 1'-0"

