


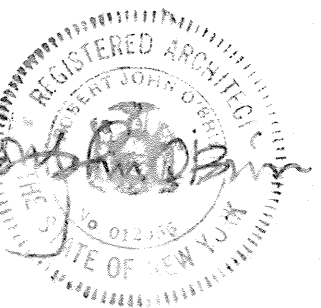




Addition to Wilson Laboratory
Cornell High Energy Synchrotron Source and Laboratory for Nuclear Studies
Cornell University, Ithaca, New York

Scale: As Noted	Date: 9 Nov 1984
Project No: 83054	Drawn by: RB

Reflected Ceiling Plan
Level 3

Details

A10

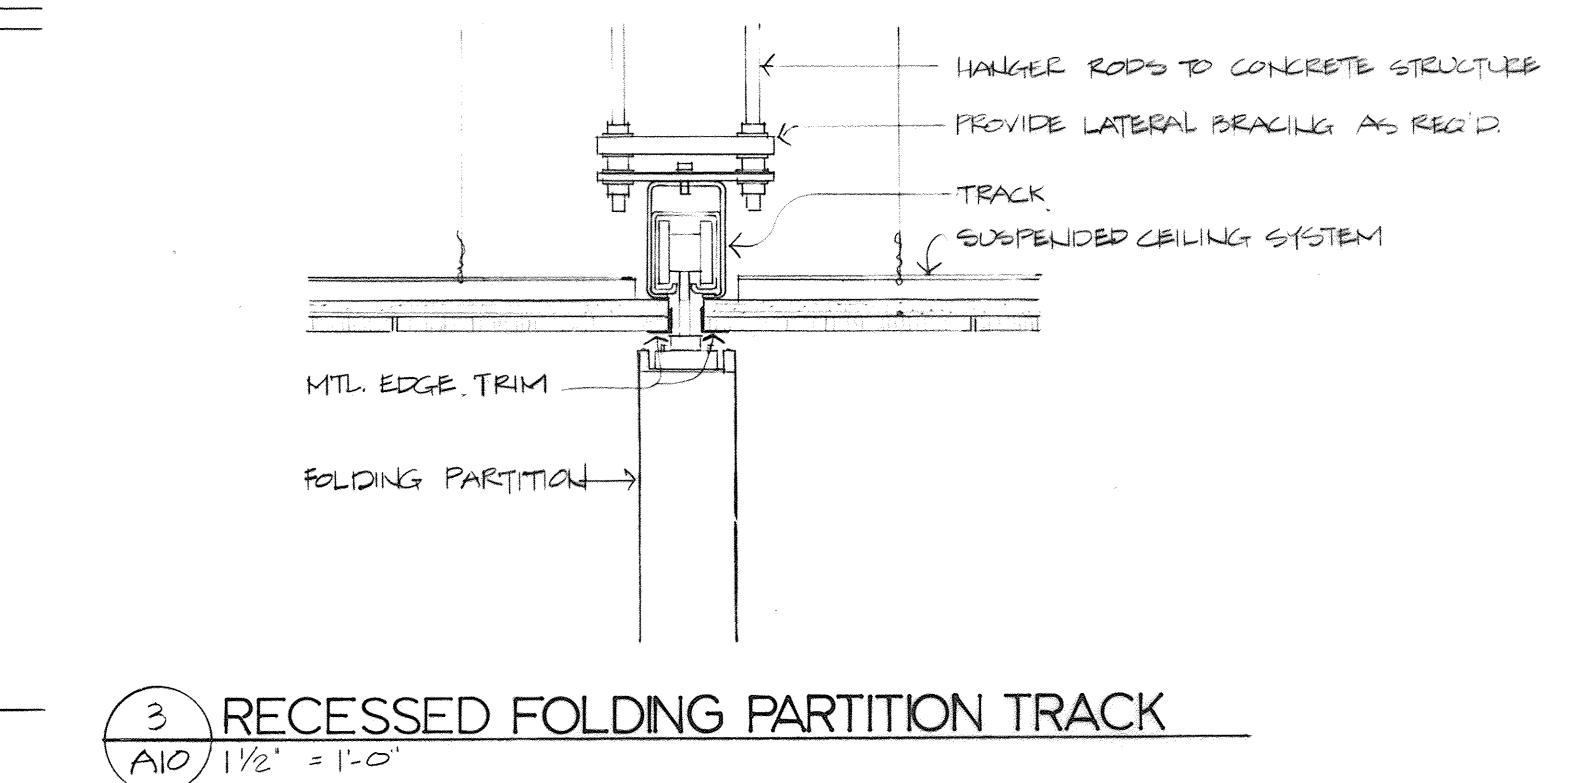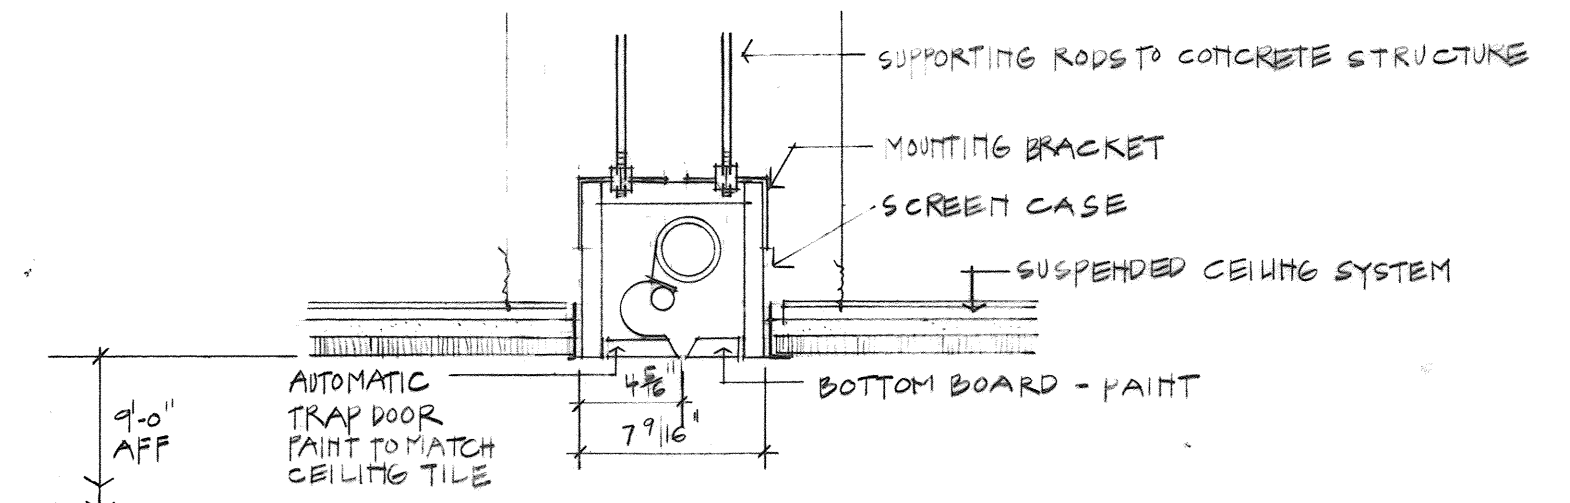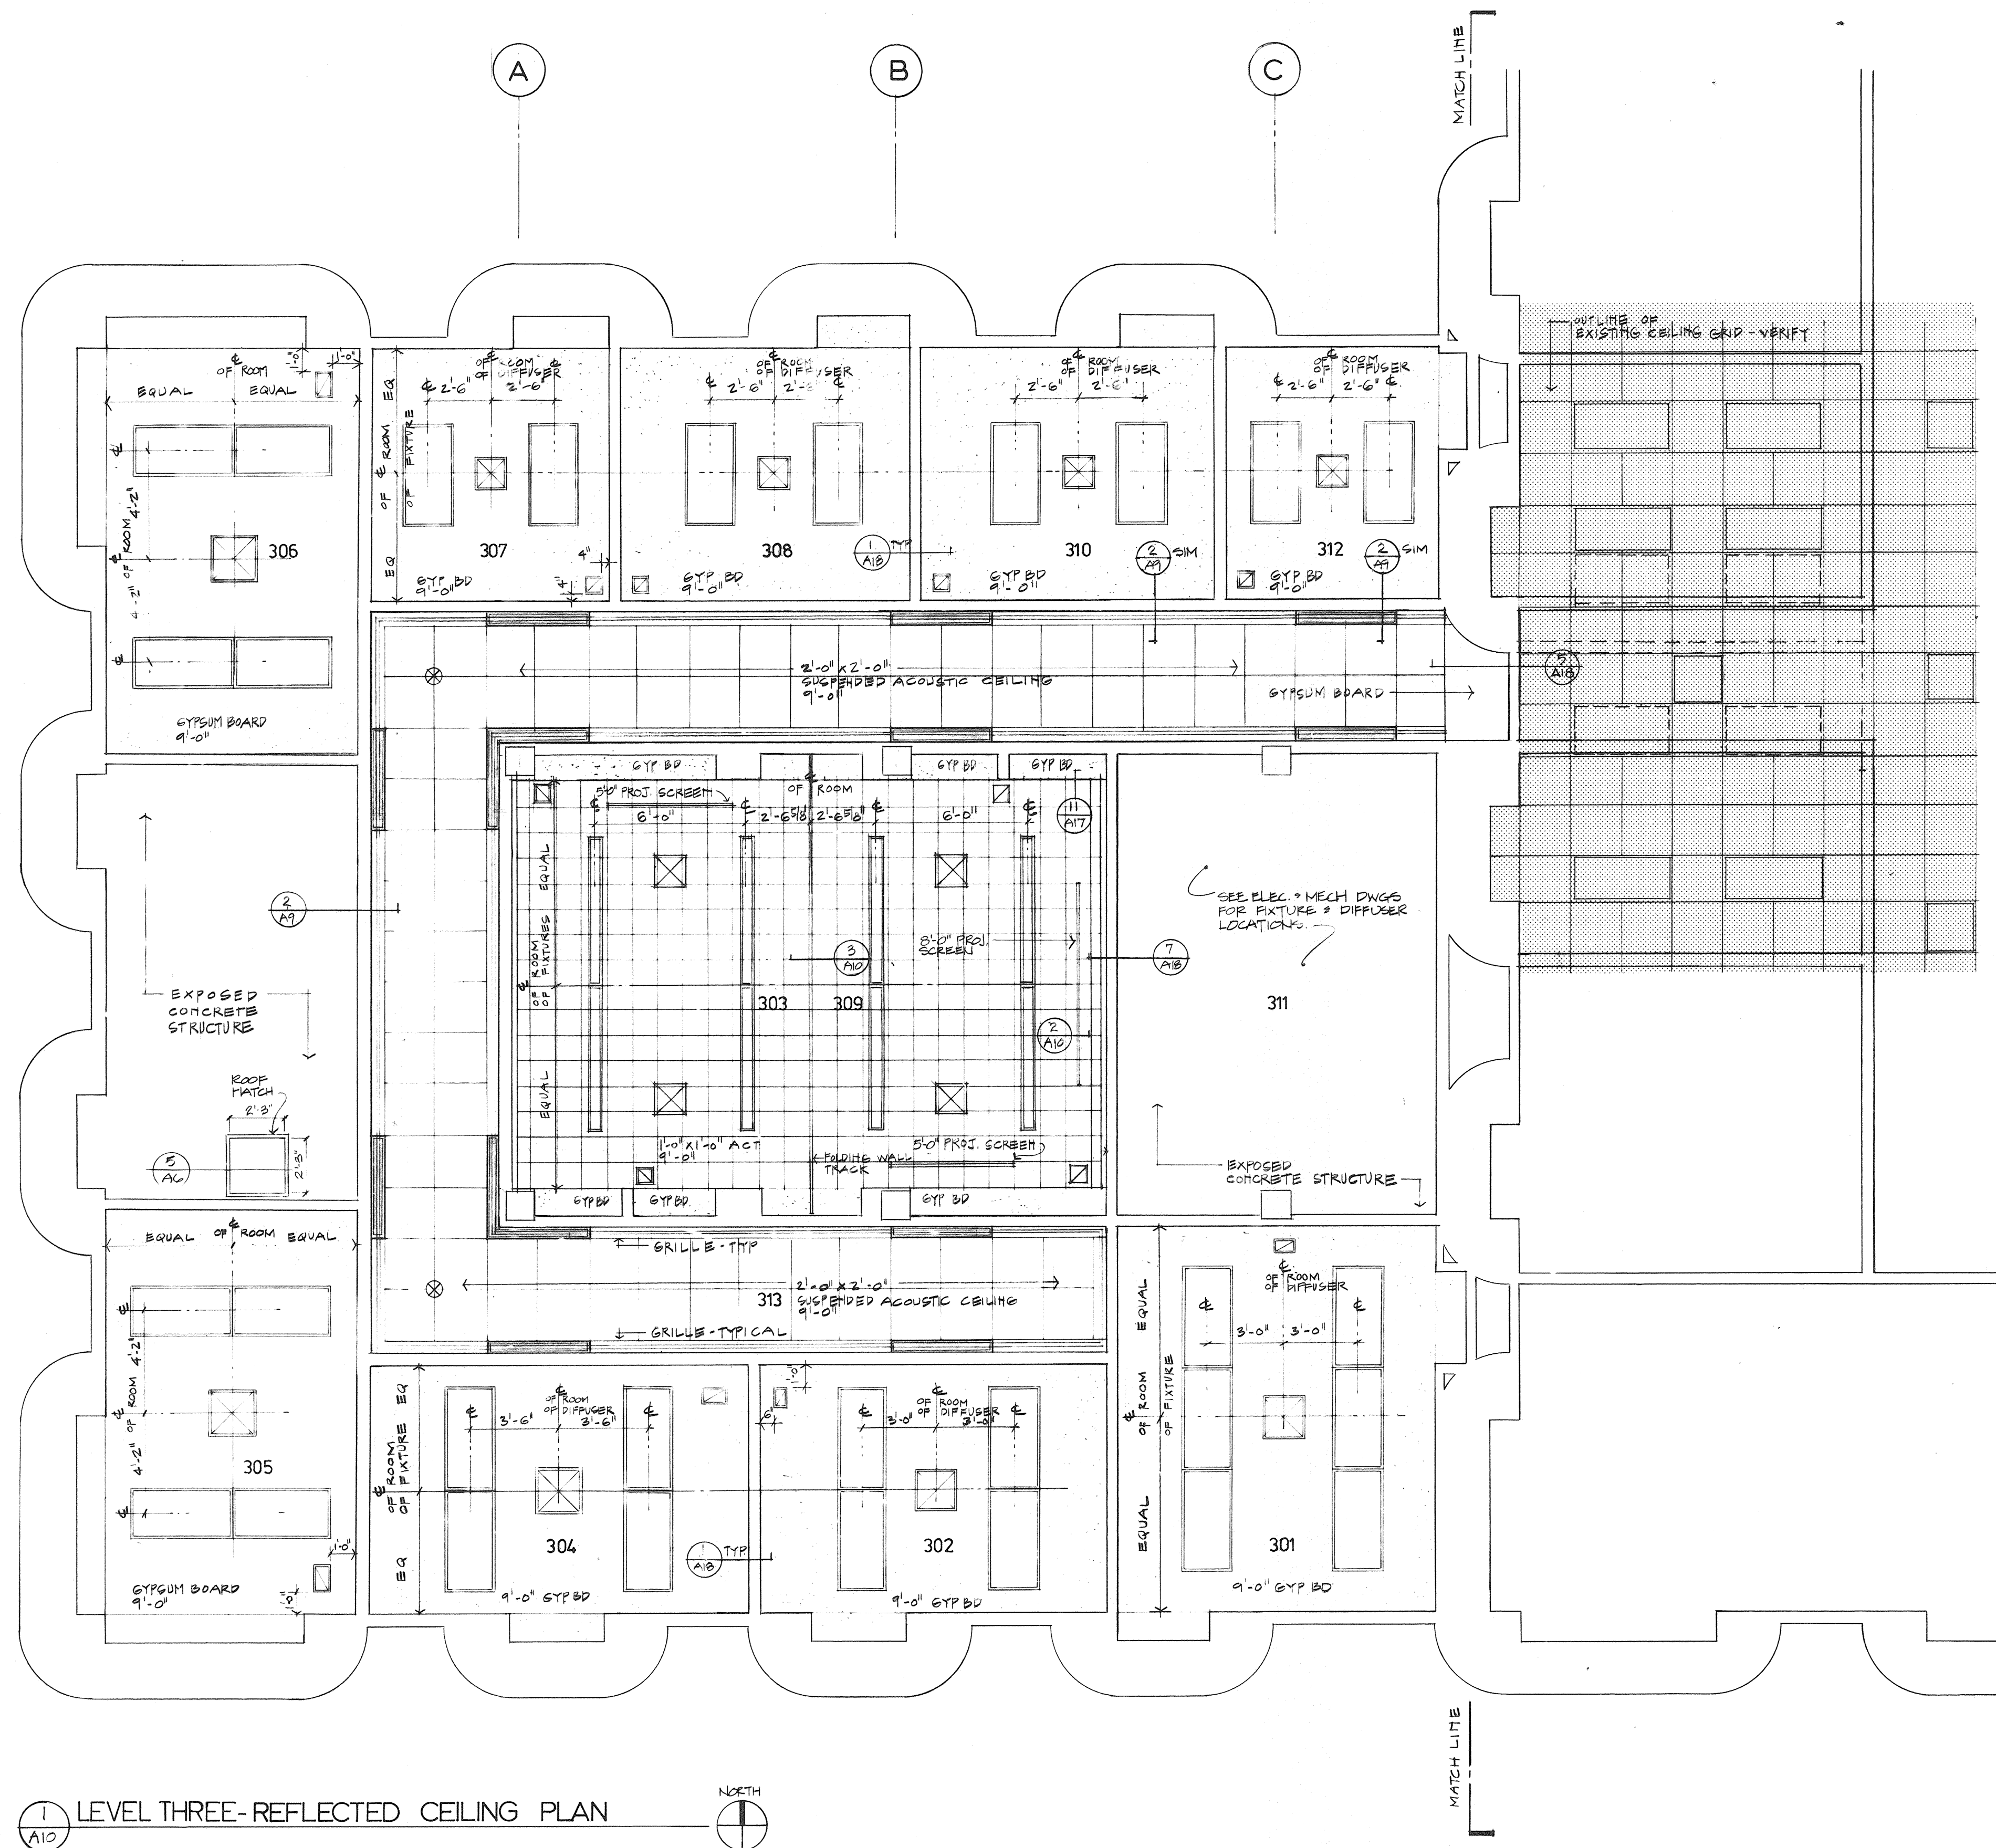

074-011