
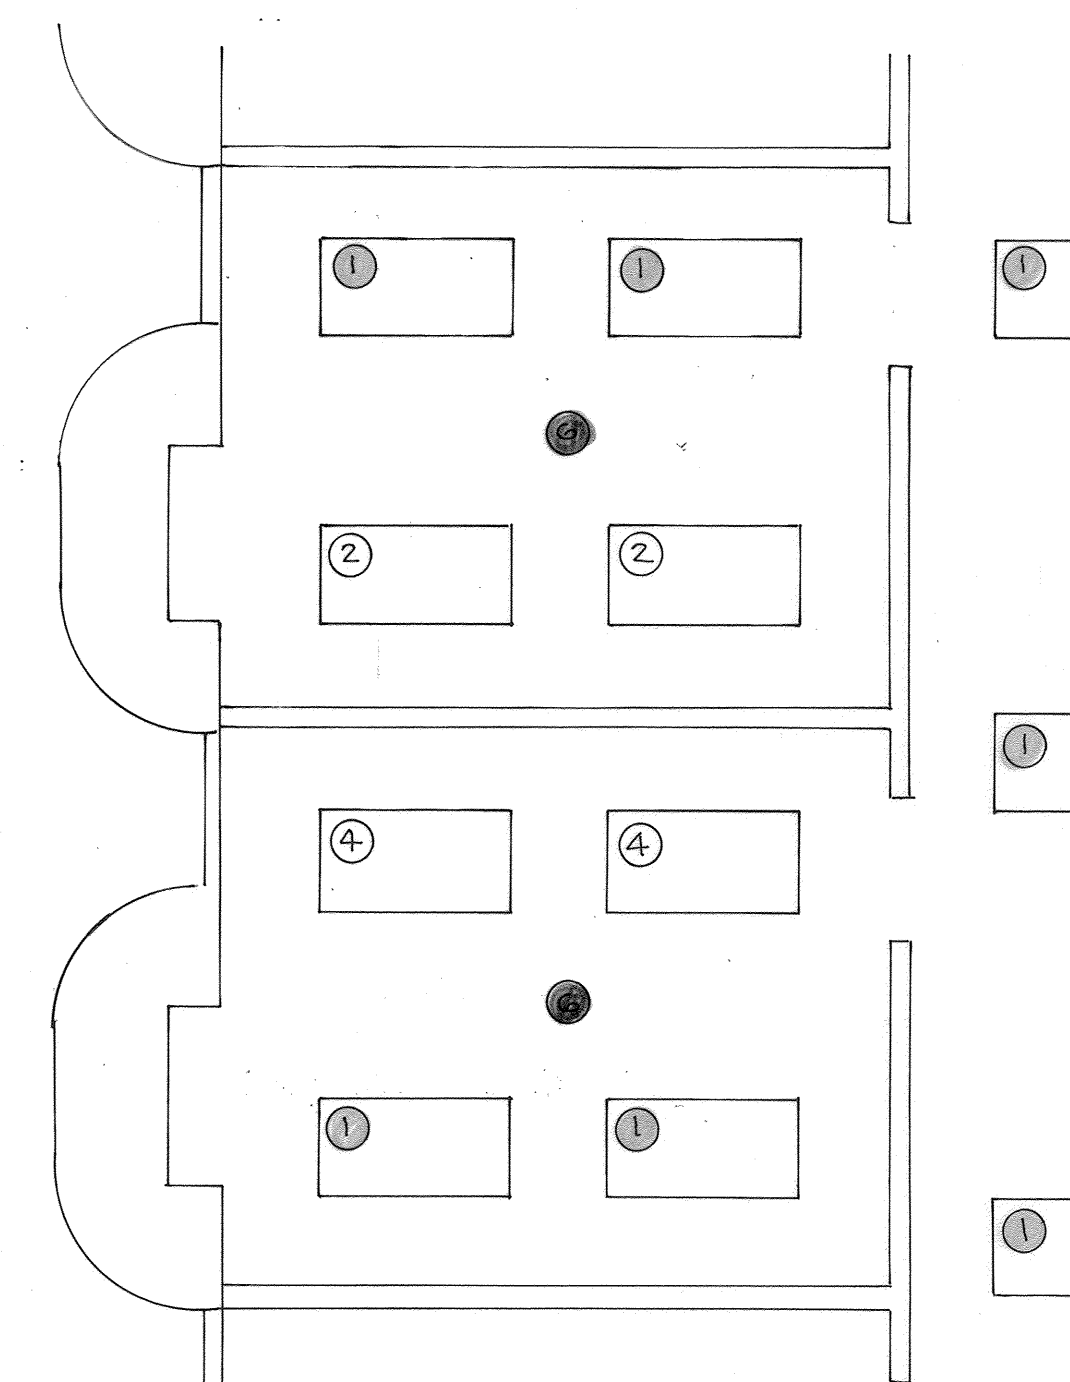


FA-8
FB-22
FE-4
FE-14
FG-12
FI-1
FO-1

X-1-1
X-2-3
X-3-1
EM-1-2
EM-2-1

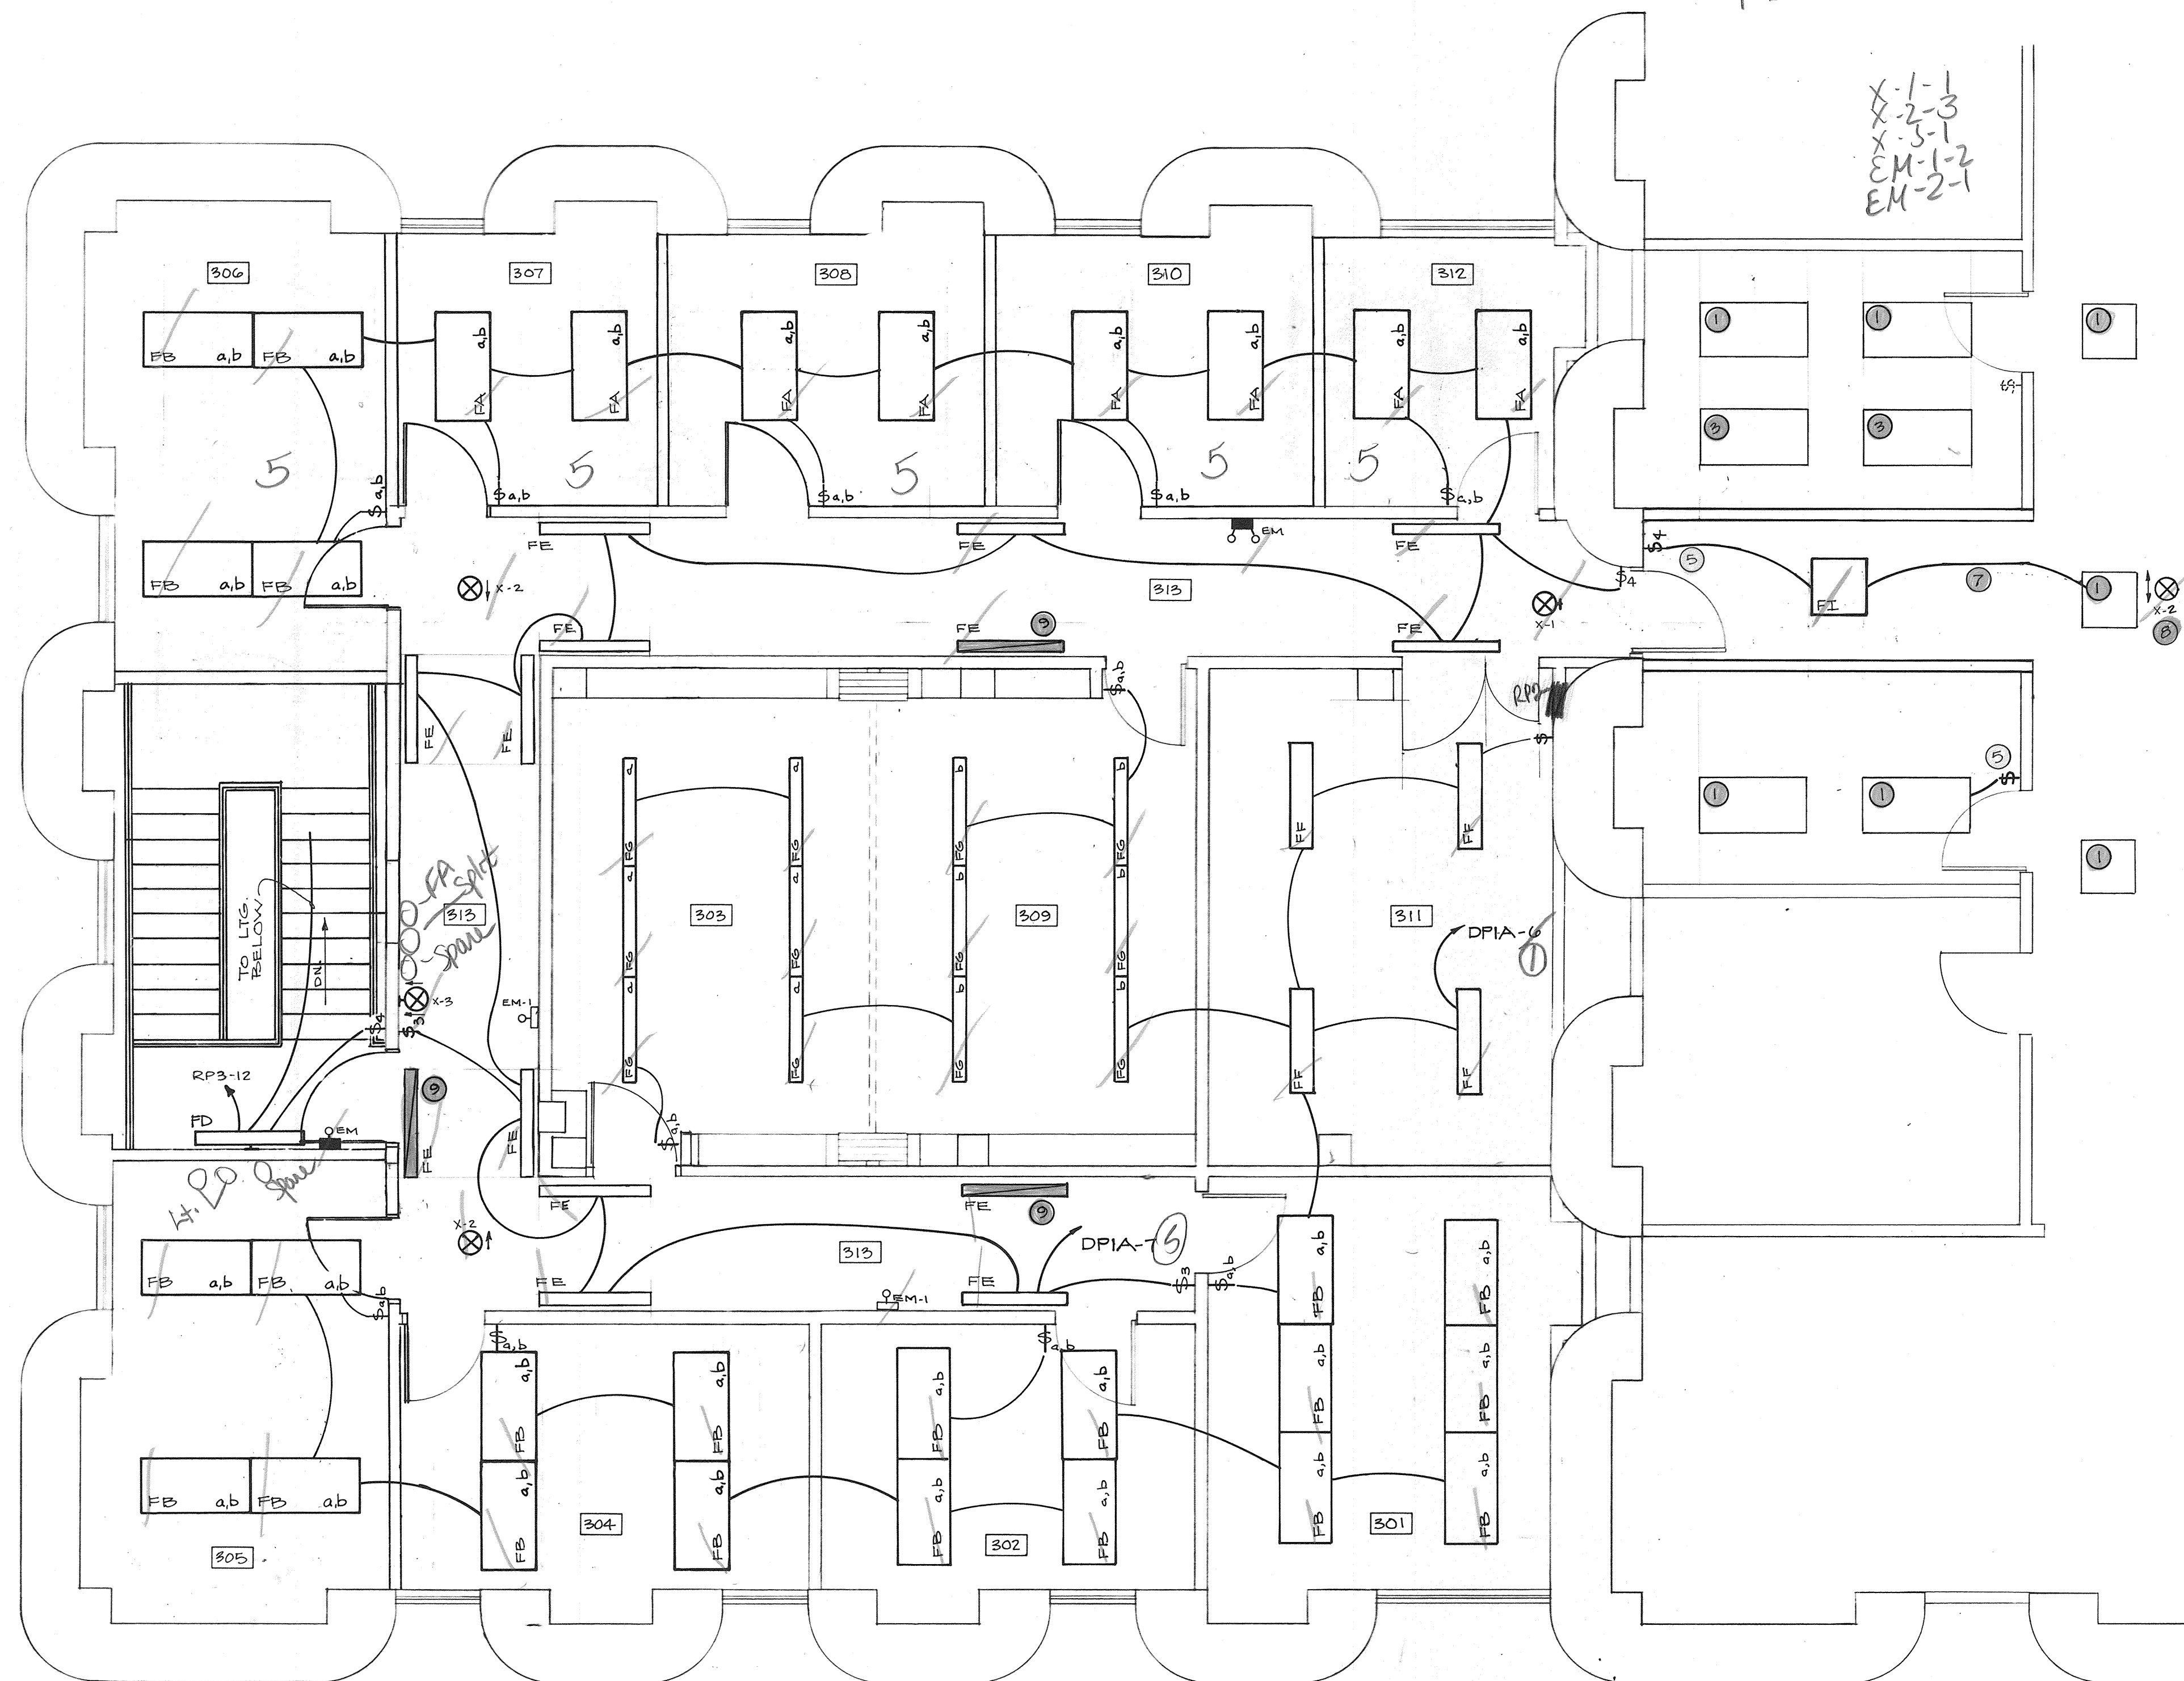

LEVEL 3
EXISTING LIGHTING
1/4" = 1'-0"




DRAWING NOTES

- ① EXISTING LIGHT FIXTURE TO REMAIN.
- ② EXISTING LIGHT FIXTURE TO BE RELOCATED.
- ③ RELOCATED LIGHT FIXTURE, MODIFY CIRCUITING AS REQUIRED.
- ④ EXISTING LIGHT FIXTURE TO BE REMOVED.
- ⑤ NEW WIRING DEVICE LOCATION, CUT IN NEW DEVICE IN EXISTING WALL, PATCH AND PAINT TO MATCH EXISTING SURROUNDINGS.
- ⑥ CONTRACTOR SHALL VERIFY EXISTING LIGHTING CIRCUITING IN THIS AREA. MODIFY EXISTING CIRCUITS AS REQUIRED TO SERVICE NEW LIGHTING LAYOUT AS SHOWN ON THE PLANS.
- ⑦ EXTEND EXISTING LIGHTING CIRCUIT AS REQUIRED TO NEW FIXTURE AND SWITCH.
- ⑧ CONNECT NEW EXIT FIXTURE TO EXISTING EXIT FIXTURE CIRCUITING IN EXISTING BUILDING.
- ⑨ NIGHT LIGHT FIXTURE, CONNECT TO NIGHT LIGHT CIRCUIT FROM PANE "DP" IN ROOM 311.
- ⑩ COORDINATE UNDERCOUNTER LIGHTING AND SWITCHING WITH ARCHITECT, IN FIELD.

ROOM SCHEDULE - LEVEL 3

No.	ROOM NAME
301	OFFICE
302	OFFICE
303	CONFERENCE
304	OFFICE
305	OFFICE
306	DIRECTOR
307	OFFICE
308	OFFICE
309	CONFERENCE
310	OFFICE
311	MECHANICAL
312	OFFICE
313	CORRIDOR

 LEVEL THREE - Lighting

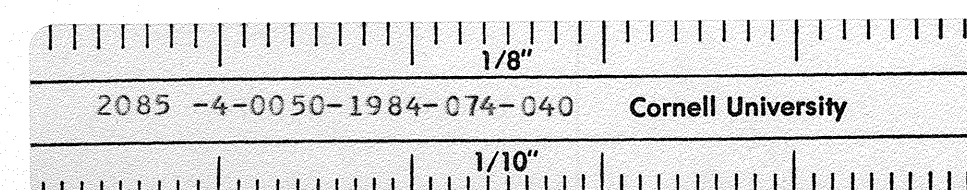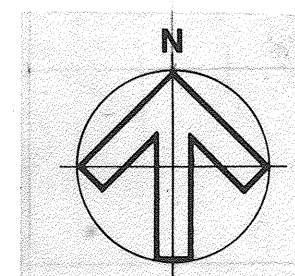

IT IS A VIOLATION OF THE NEW YORK STATE EDUCATION LAW FOR ANY PERSON, UNLESS HE IS ACTING UNDER THE DIRECTION OF A LICENSED PROFESSIONAL ENGINEER, TO ALTER AN ITEM ON THIS DOCUMENT IN ANY WAY.