


FACILITIES ENGINEERING

J.W. HUMPHREYS SERVICE BUILDING
CORNELL UNIVERSITY
ITHACA N.Y. 14853

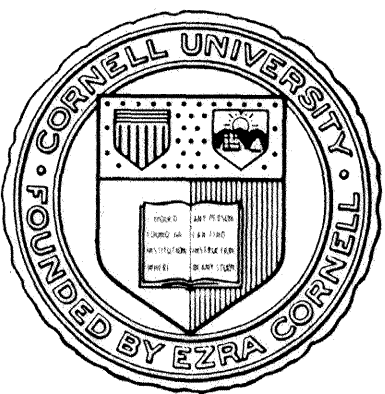

APPROVAL DATE

Philip Z. Cori 11 May 89
FACILITIES ENGINEERING

LIFE SAFETY

DRAWN BY DATE
P. KILPATRICK 05/10/89

CHECKED BY

ARCH	<i>AKS</i>	ENERGY	_____
CIVIL	<i>AKS</i>	ENVIR	_____
ELEC	<i>AKS</i>		_____
MECH	<i>AKS</i>		_____
STRUCT			_____


REV DATE BY DESCRIPTION

DRAWING TITLE


1/8" SCALE
BUILDING PLAN

PROJECT
WILSON LAB
BL-3 FACILITY

LOCATION NO. 2085

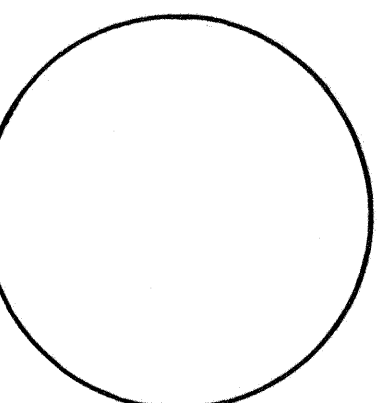

SCALE AS NOTED	SHEET NO.
FILE NO. 85330	A-2
DRAWING NO. D-2819	095-111

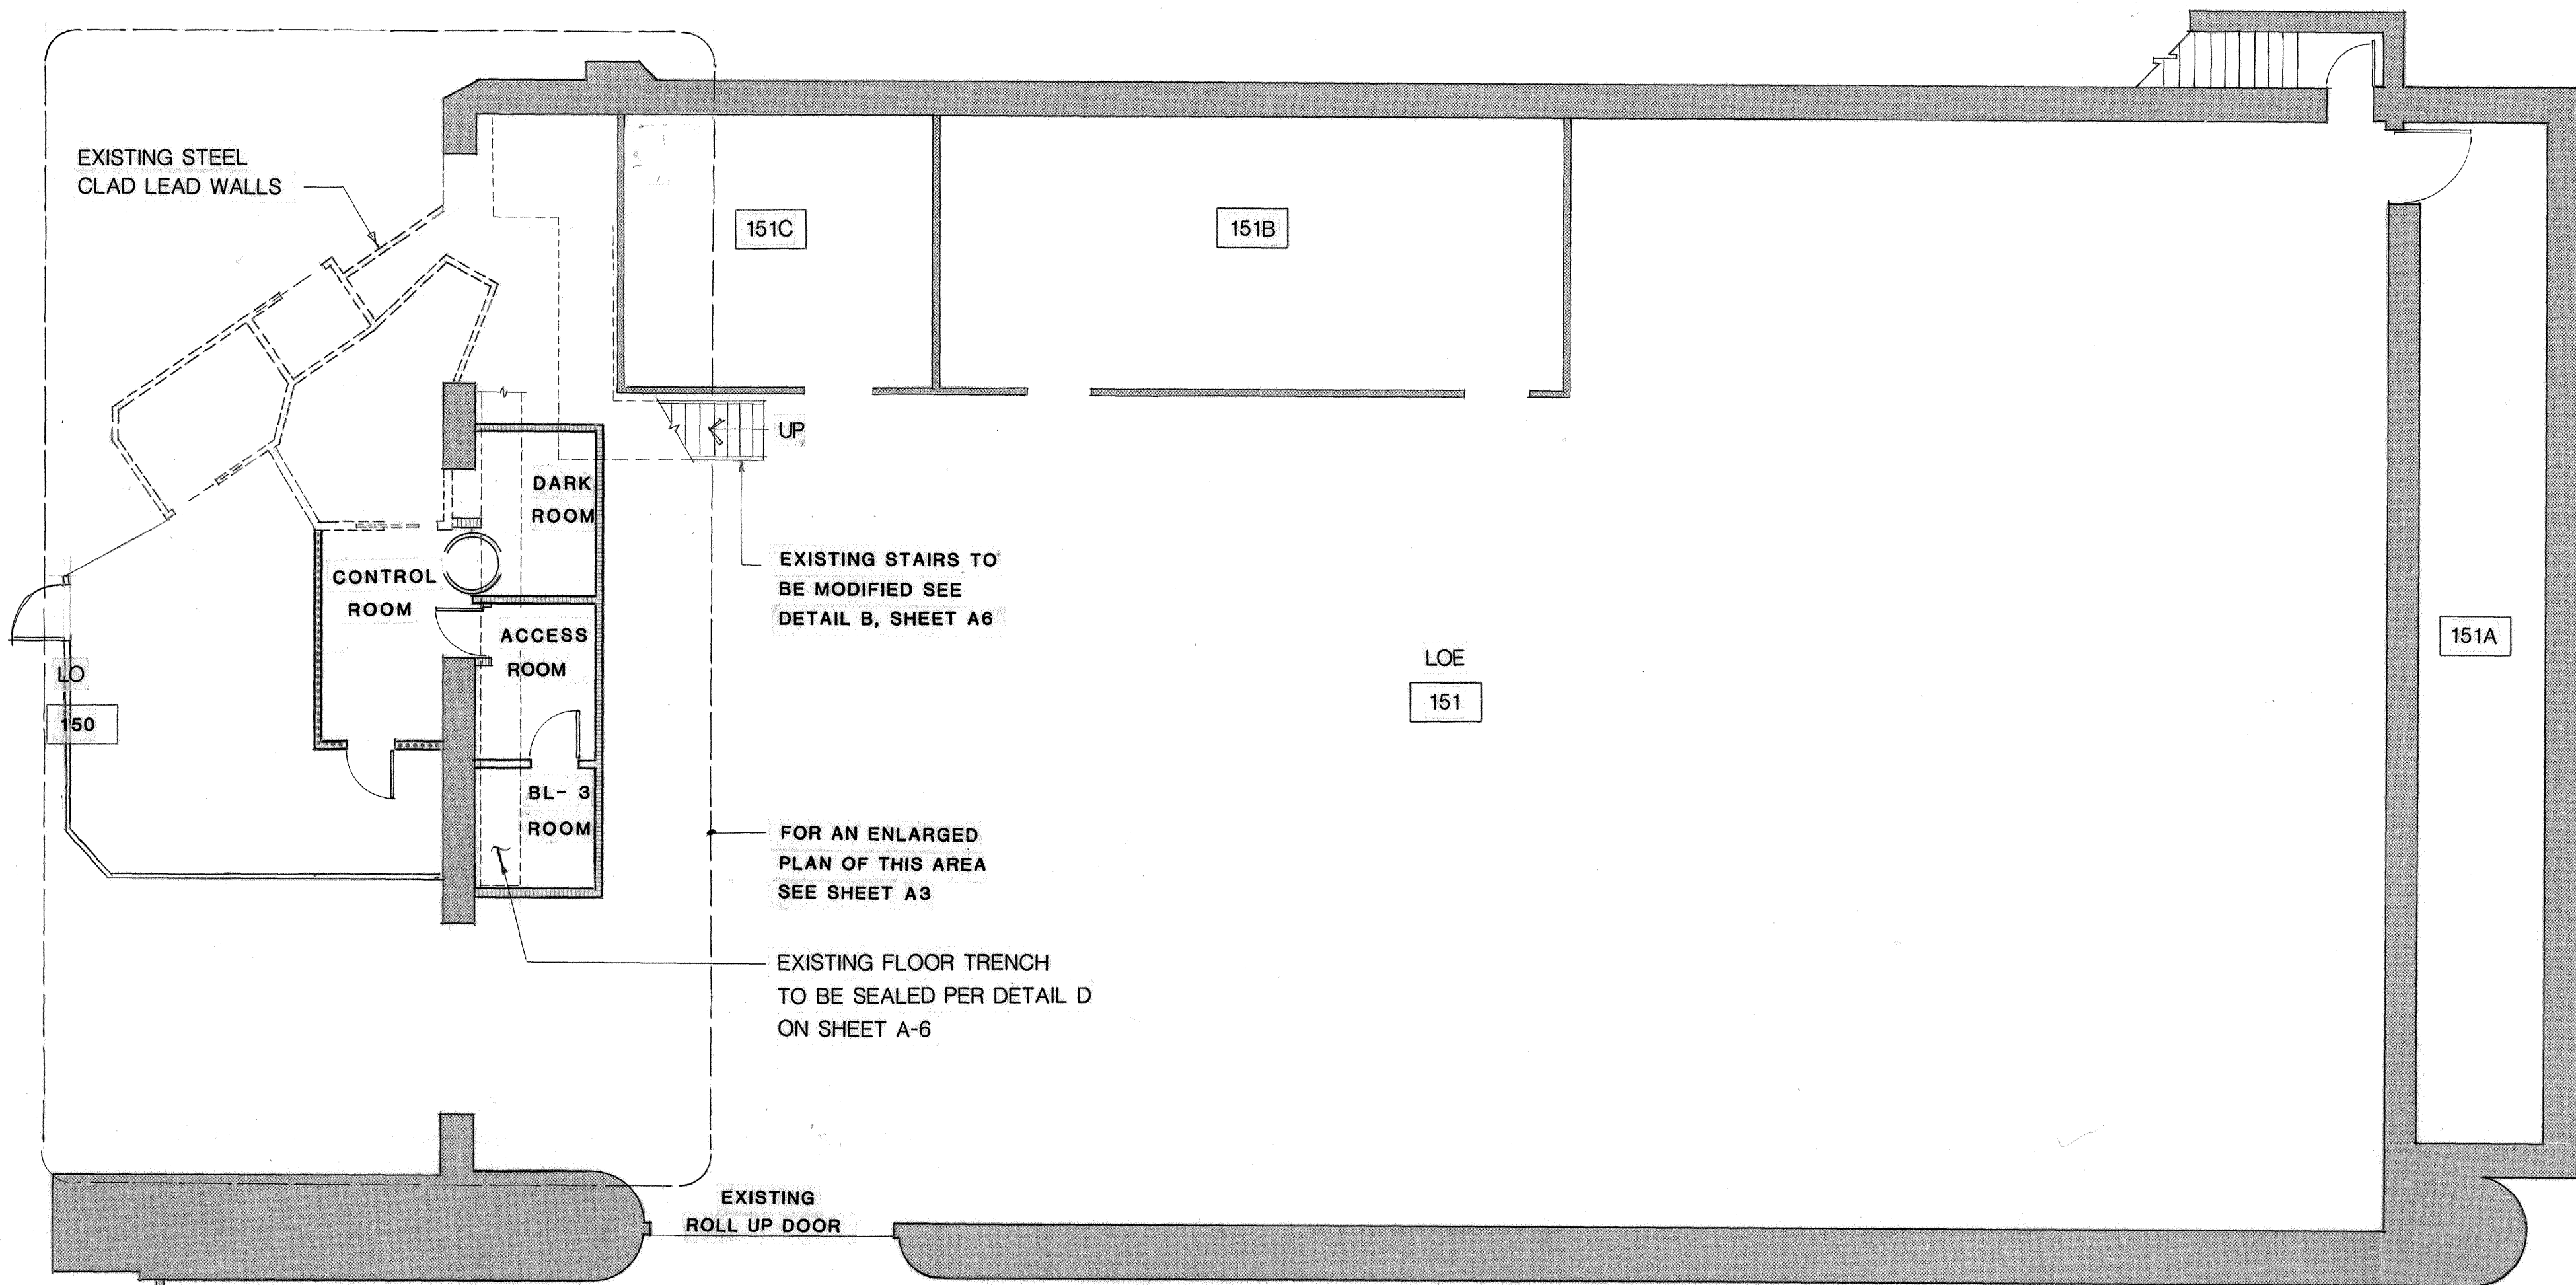

LEGEND

SYMBOL	DESCRIPTION
	EXISTING WALLS
	EXISTING LEAD/STEEL WALLS
	NEW UNINSULATED WALLS
	INSULATED WALLS WITH FIBERGLASS & THERMAX
	INSULATED WALLS WITH FIBERGLASS ONLY

note: use of the above symbols
referring to insulation are
typical for this sheet only

N
1/8" SCALE FLOOR PLAN
SCALE 1/8" : 1' - 0"