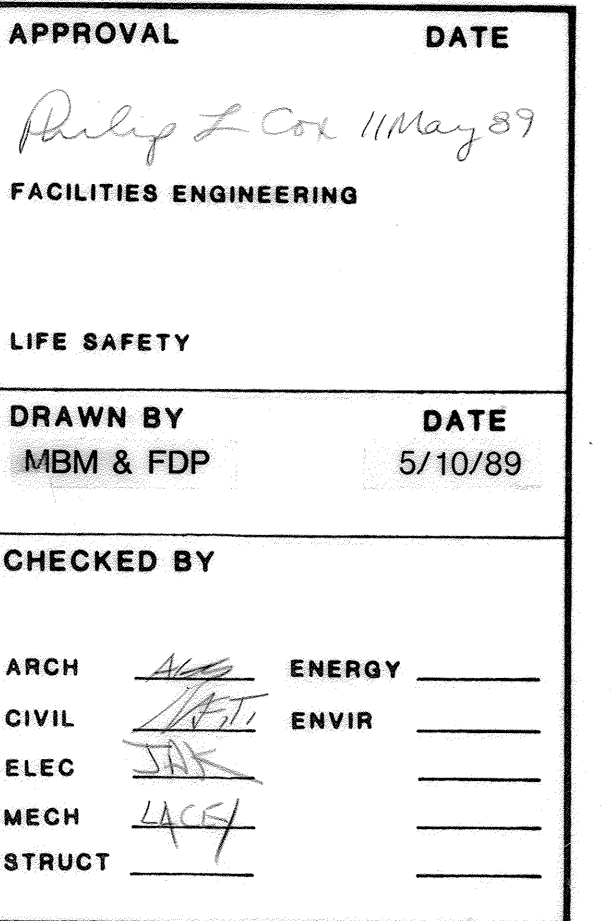


[illegible]

DRAWING TITLE

POWER PLAN

PROJECT

WILSON LAB
BL-3 FACILITY

LOCATION NO. 2085



SCALE	SHEET NO. E2 <i>095-117</i>
AS NOTED	
FILE NO. 85330	
DRAWING NO. D-2819	


1ST FLOOR POWER PLAN
 SCALE 1/4" = 1' - 0"

