



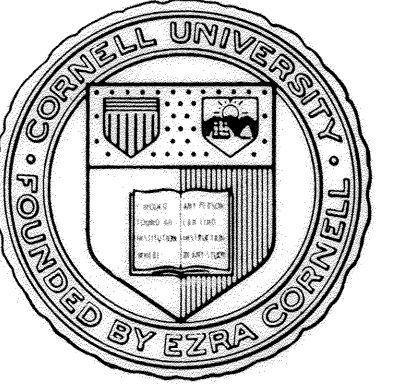

APPROVAL	DATE
<i>Philip L. Cole</i>	11 May 89
FACILITIES ENGINEERING	
LIFE SAFETY	
DRAWN BY	DATE
D. SMITH	05/10/89
CHECKED BY	
ARCH <i>ACE</i>	ENERGY
CIVIL <i>ACE</i>	ENVIR
ELEC <i>ACE</i>	
MECH <i>ACE</i>	
STRUCT	


REV	DATE	BY	DESCRIPTION

DRAWING TITLE
ALTERATIONS
LEVEL 4
PROJECT
WILSON LAB BL-3 FACILITY
LOCATION NO. 2085

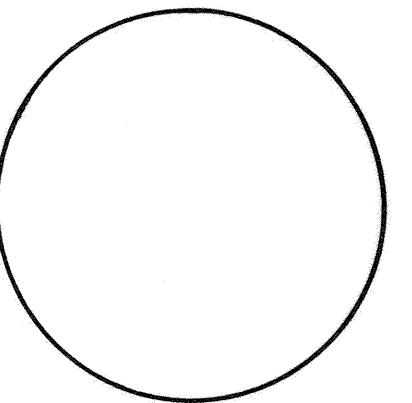


CORNELL UNIVERSITY LIBRARY
3 1924 122 779 384

SCALE AS NOTED	SHEET NO.
FILE NO. 85330	M-4
DRAWING NO. D-2819	095-122

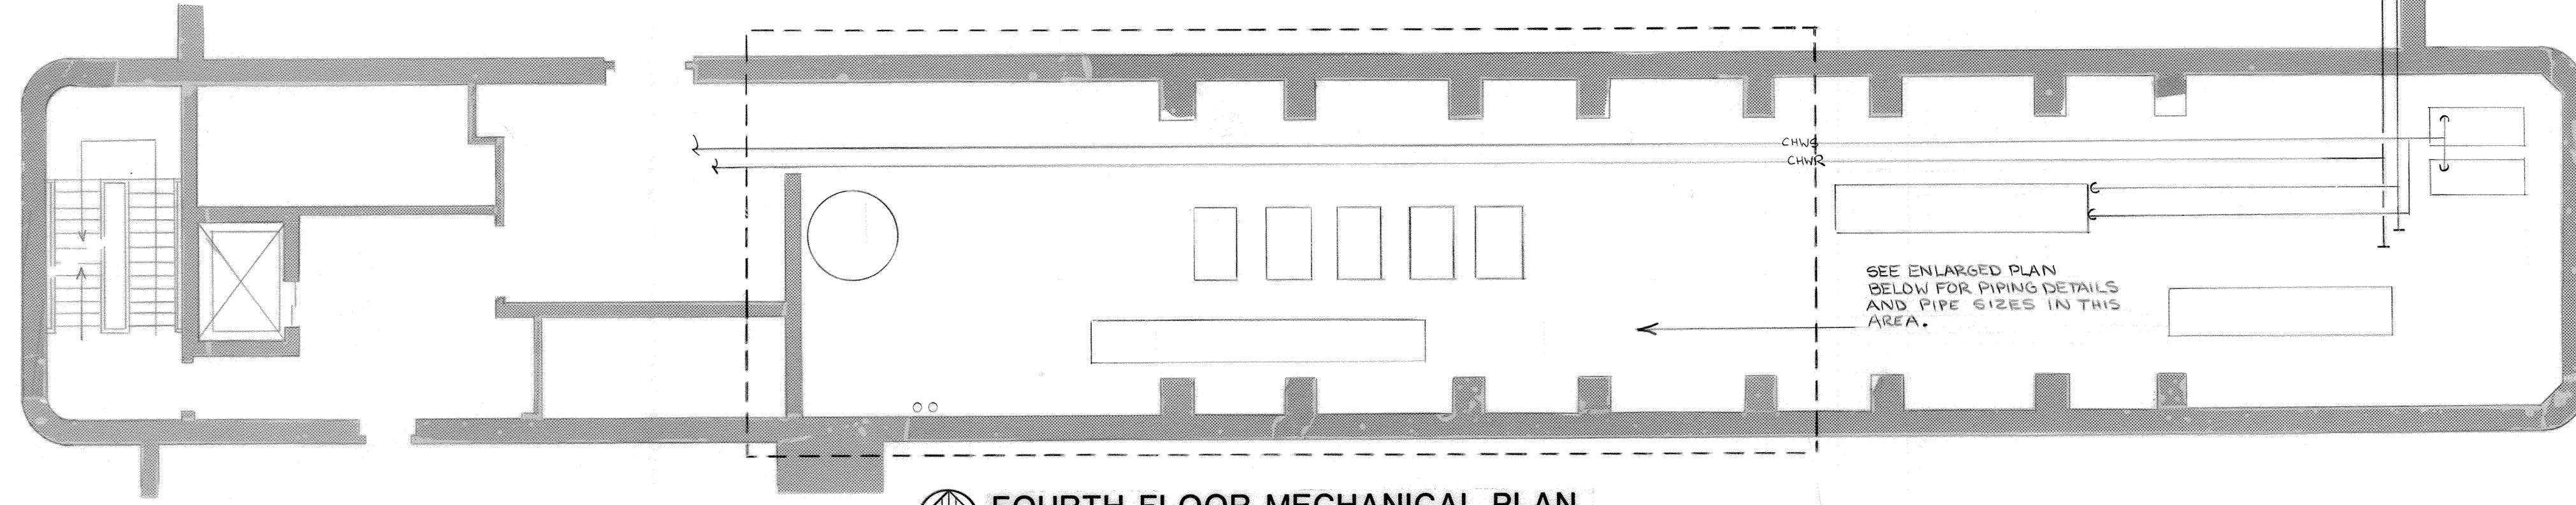

FOURTH FLOOR MECHANICAL PLAN
SCALE 1/8" : 1'-0"

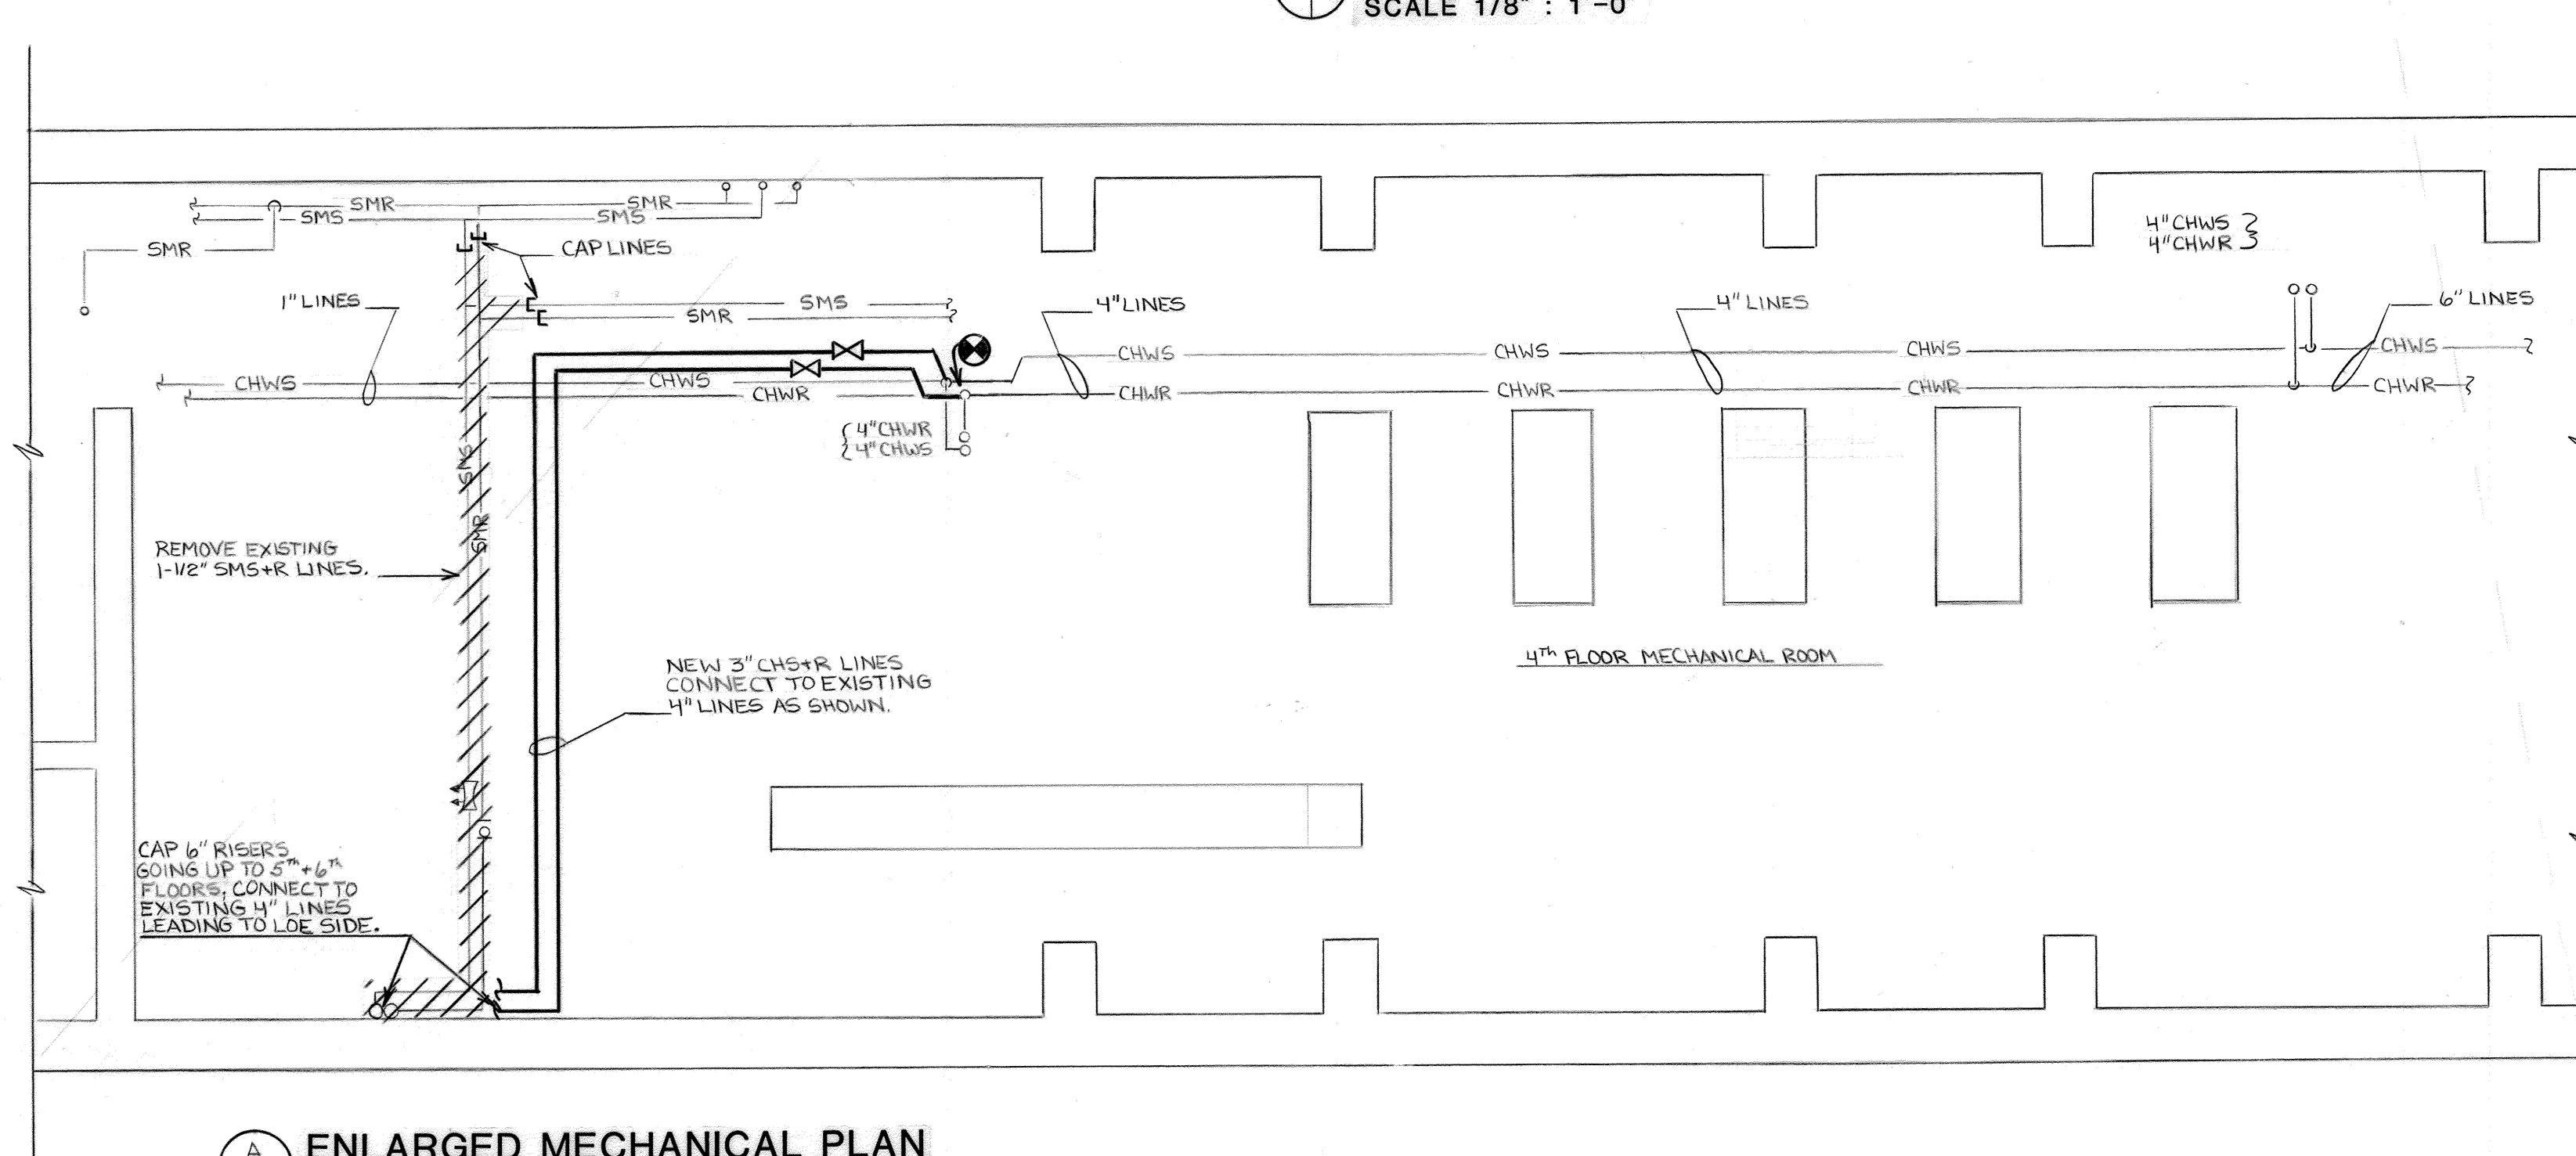

ENLARGED MECHANICAL PLAN
SCALE 1/4" : 1'-0"