


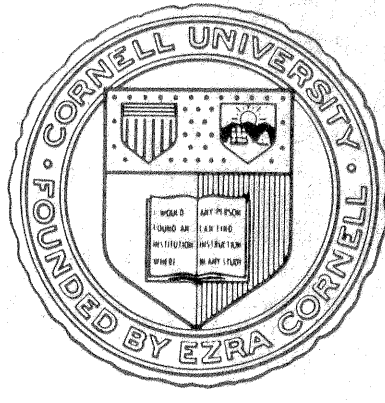

APPROVAL DATE
Philip L Cox 8/8/89
FACILITIES ENGINEERING

LIFE SAFETY

DRAWN BY DATE
DCS 8/8/89

CHECKED BY

ARCH *ACS* ENERGY
CIVIL *LF* ENVIR
ELEC *JAR*
MECH *ACS*
STRUCT

REV DATE BY DESCRIPTION


DRAWING TITLE
LOE MEZZANINE

PROJECT
WILSON LAB
CESR COOLING
TOWERS


LOCATION NO. 2085

SCALE AS NOTED
FILE NO. 85610
DRAWING NO. D- 2849
SHEET NO. M1
13 OF 20


095-145

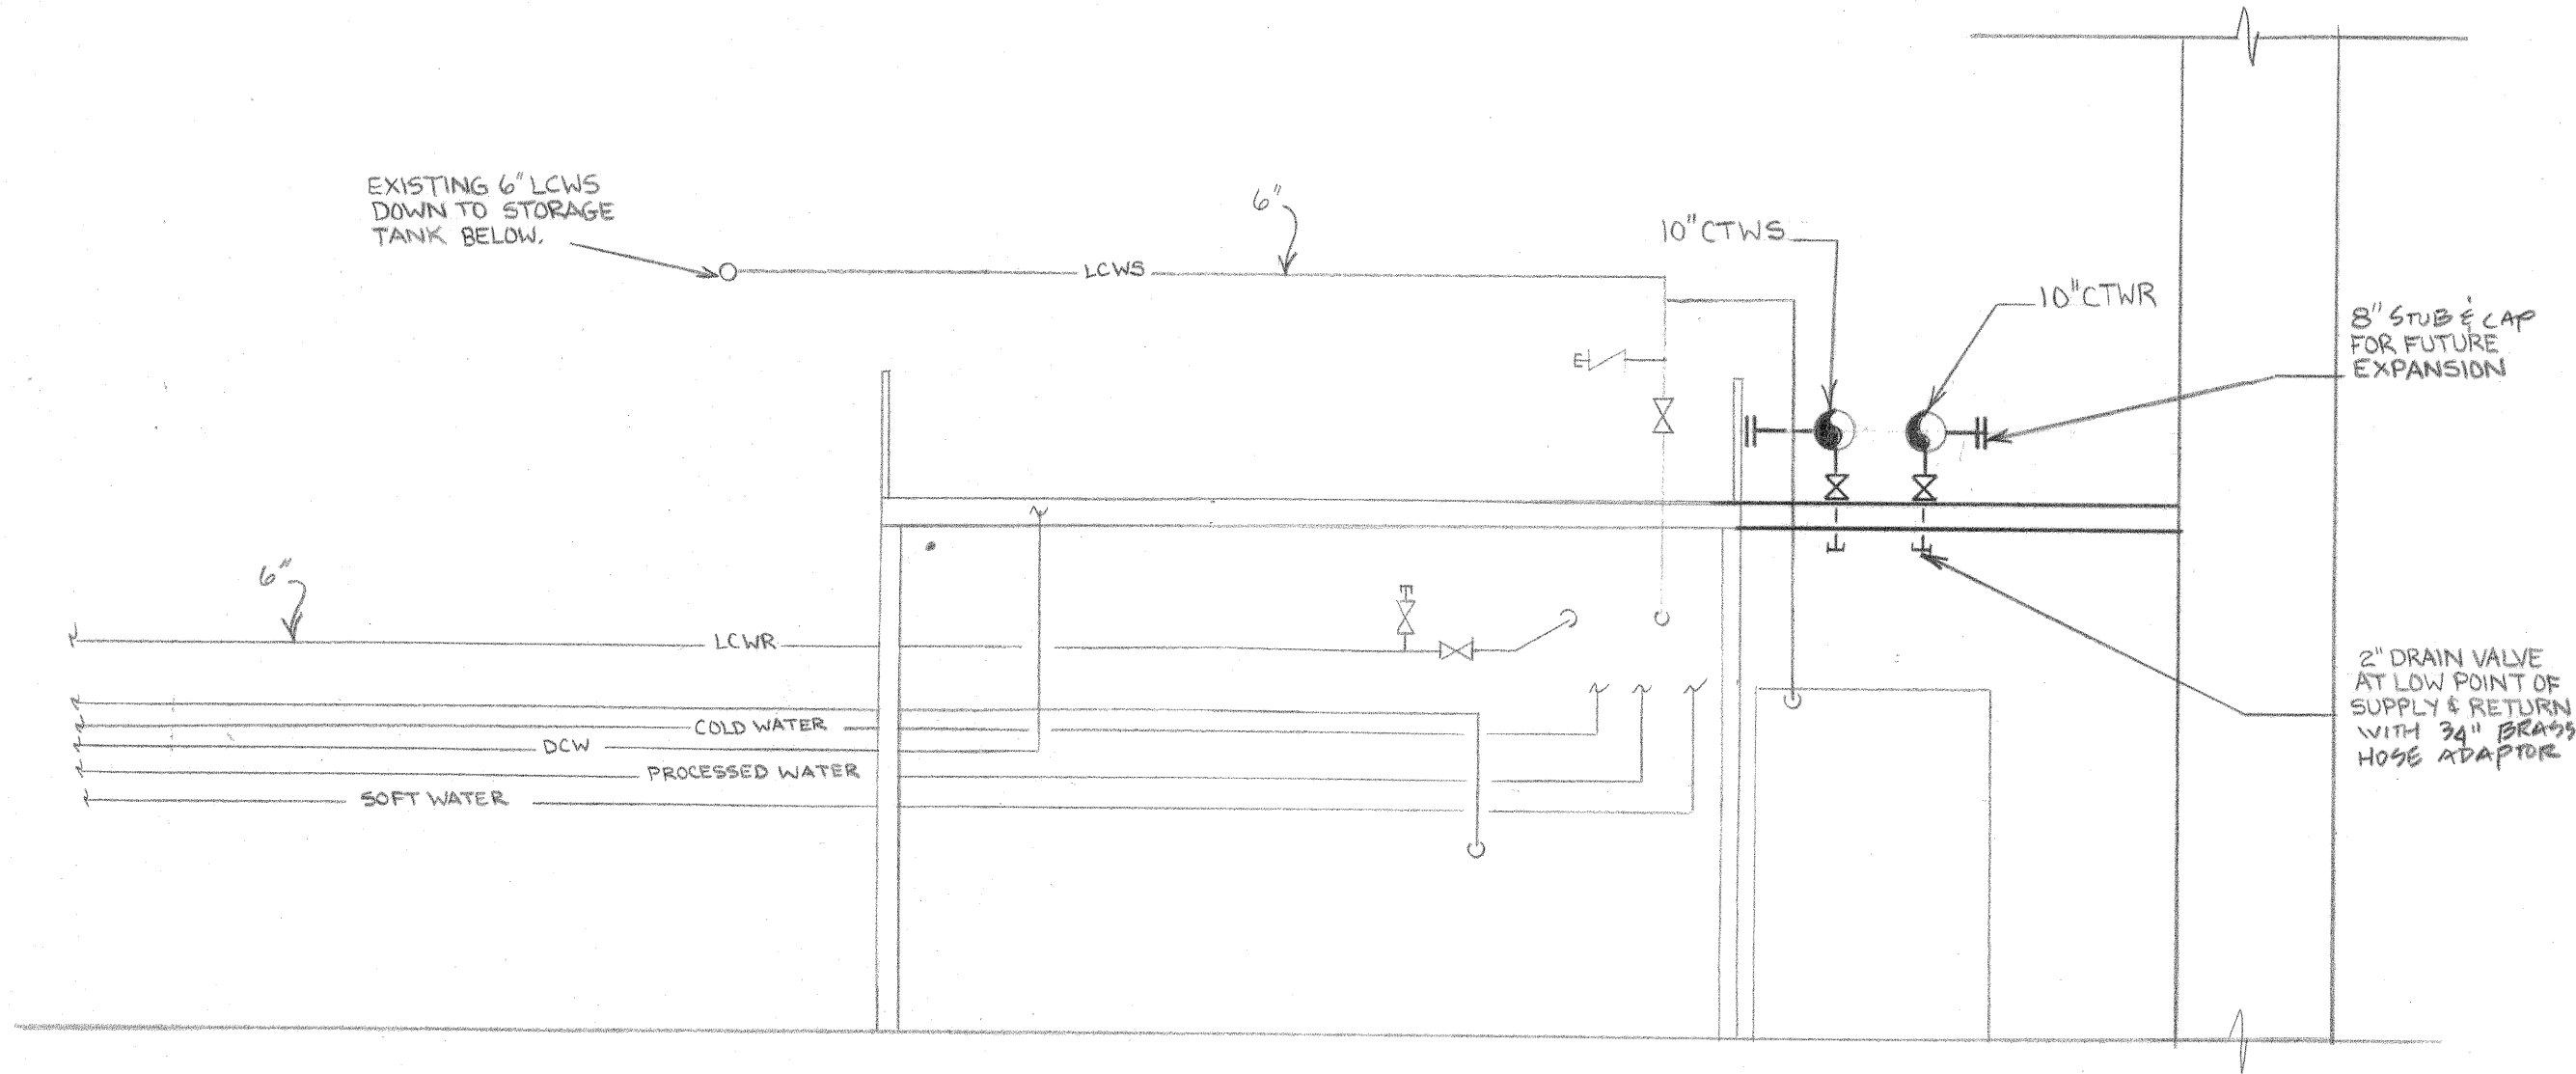


SECTION A
SCALE 1/4" : 1'-0"

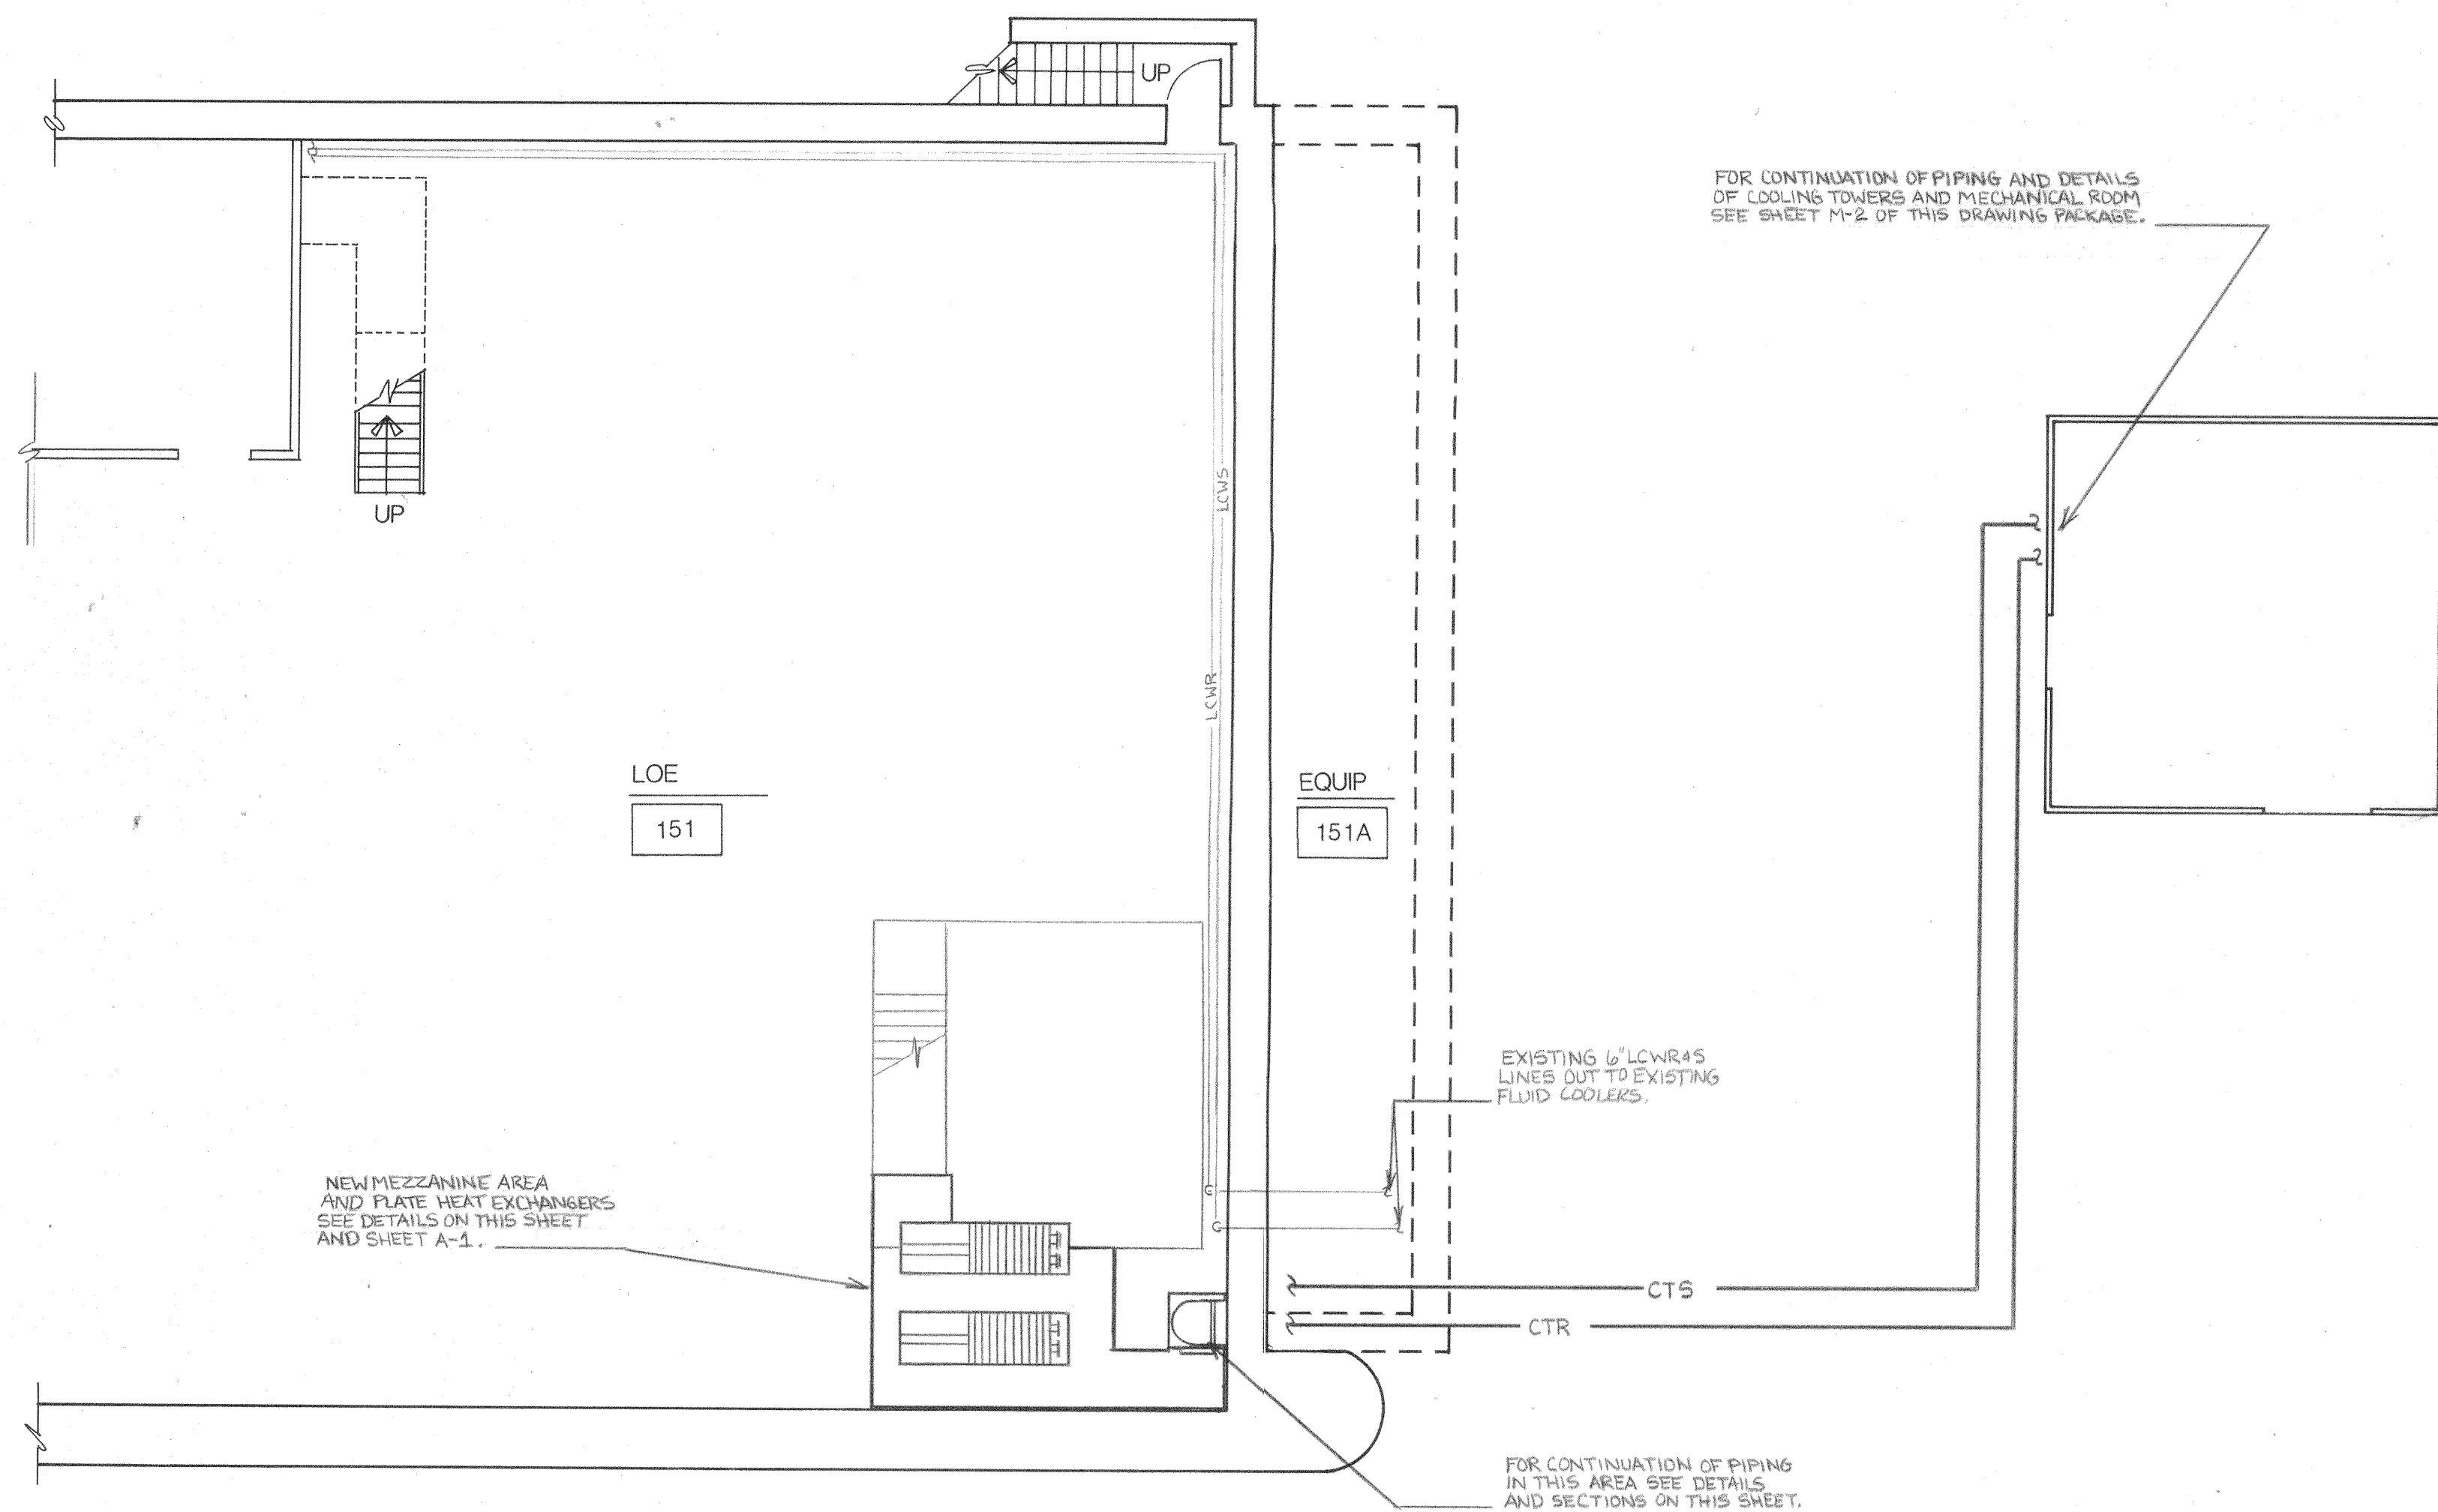

MECHANICAL PLAN LOE MEZZANINE
SCALE 1/8" : 1'-0"

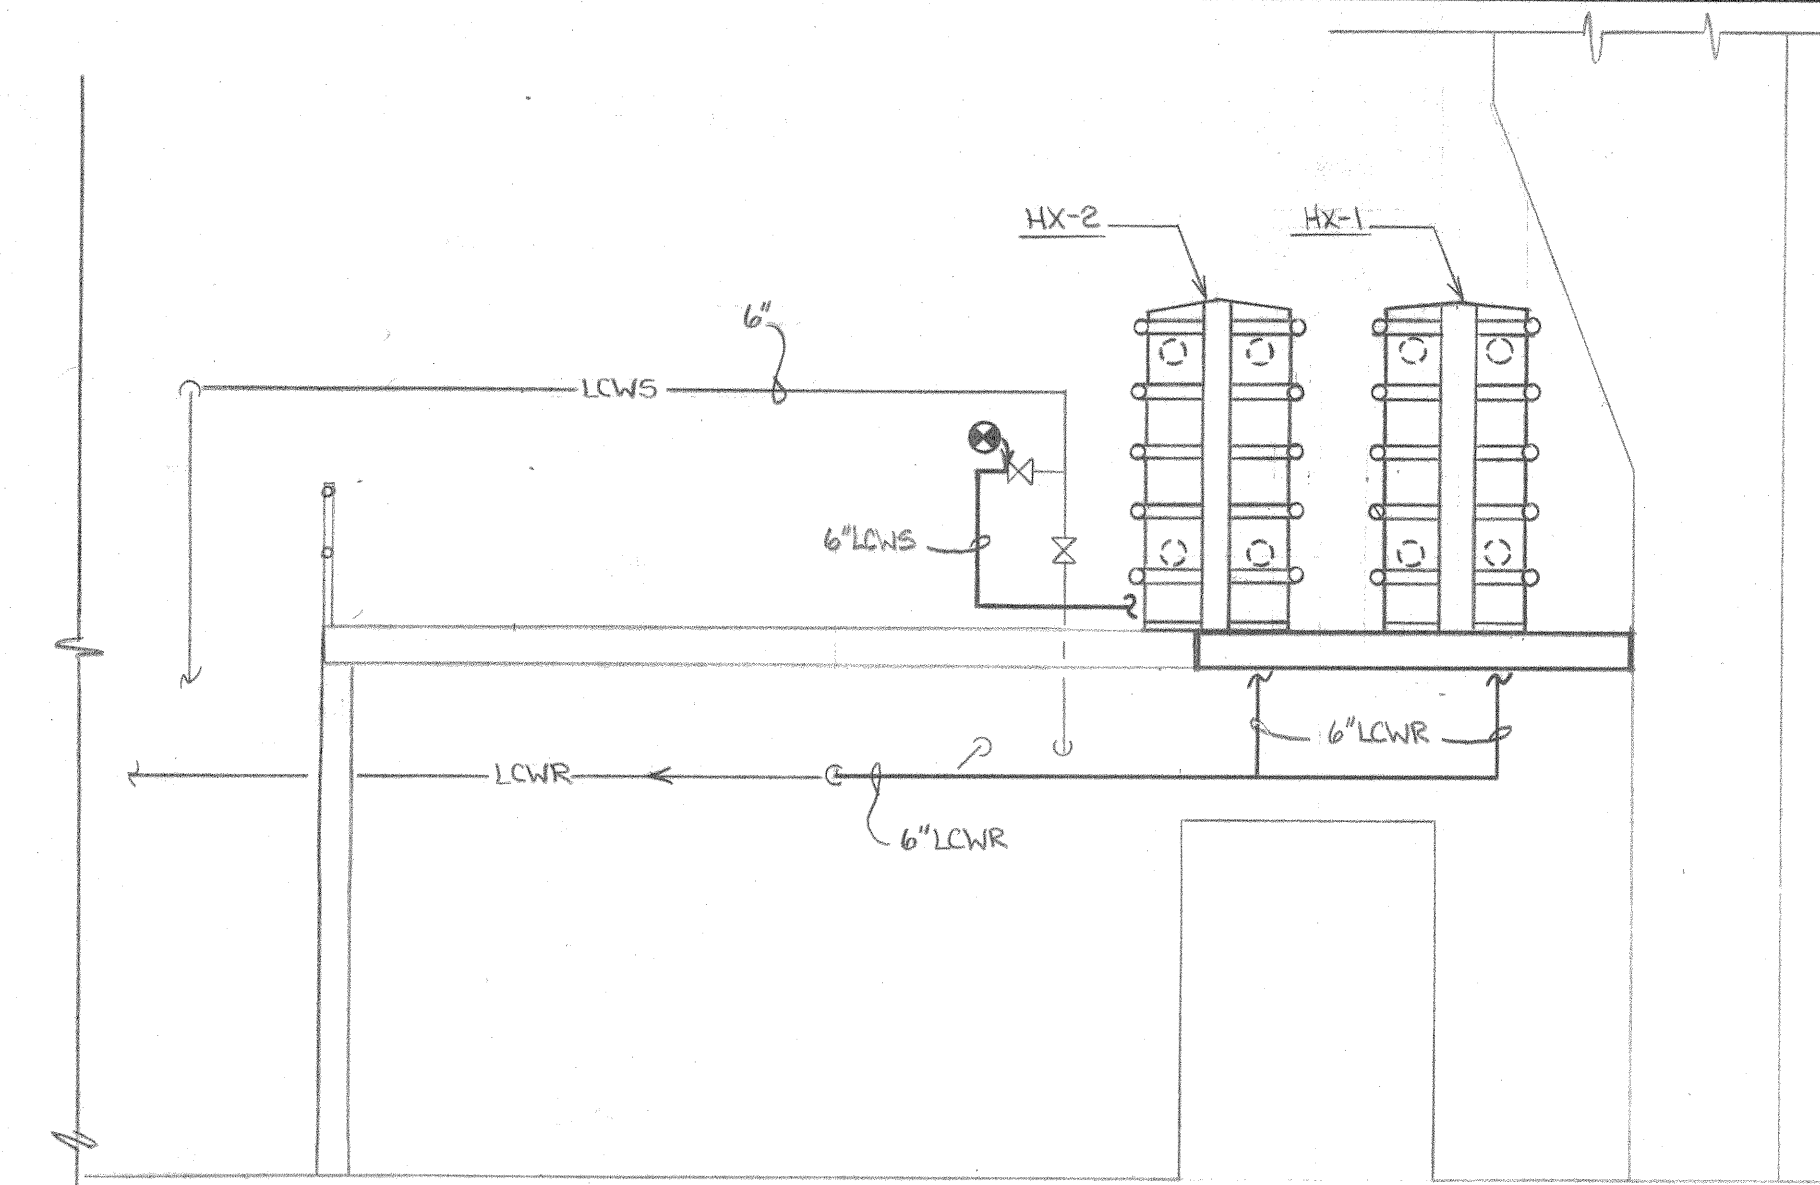

SECTION B
SCALE 1/4" : 1'-0"

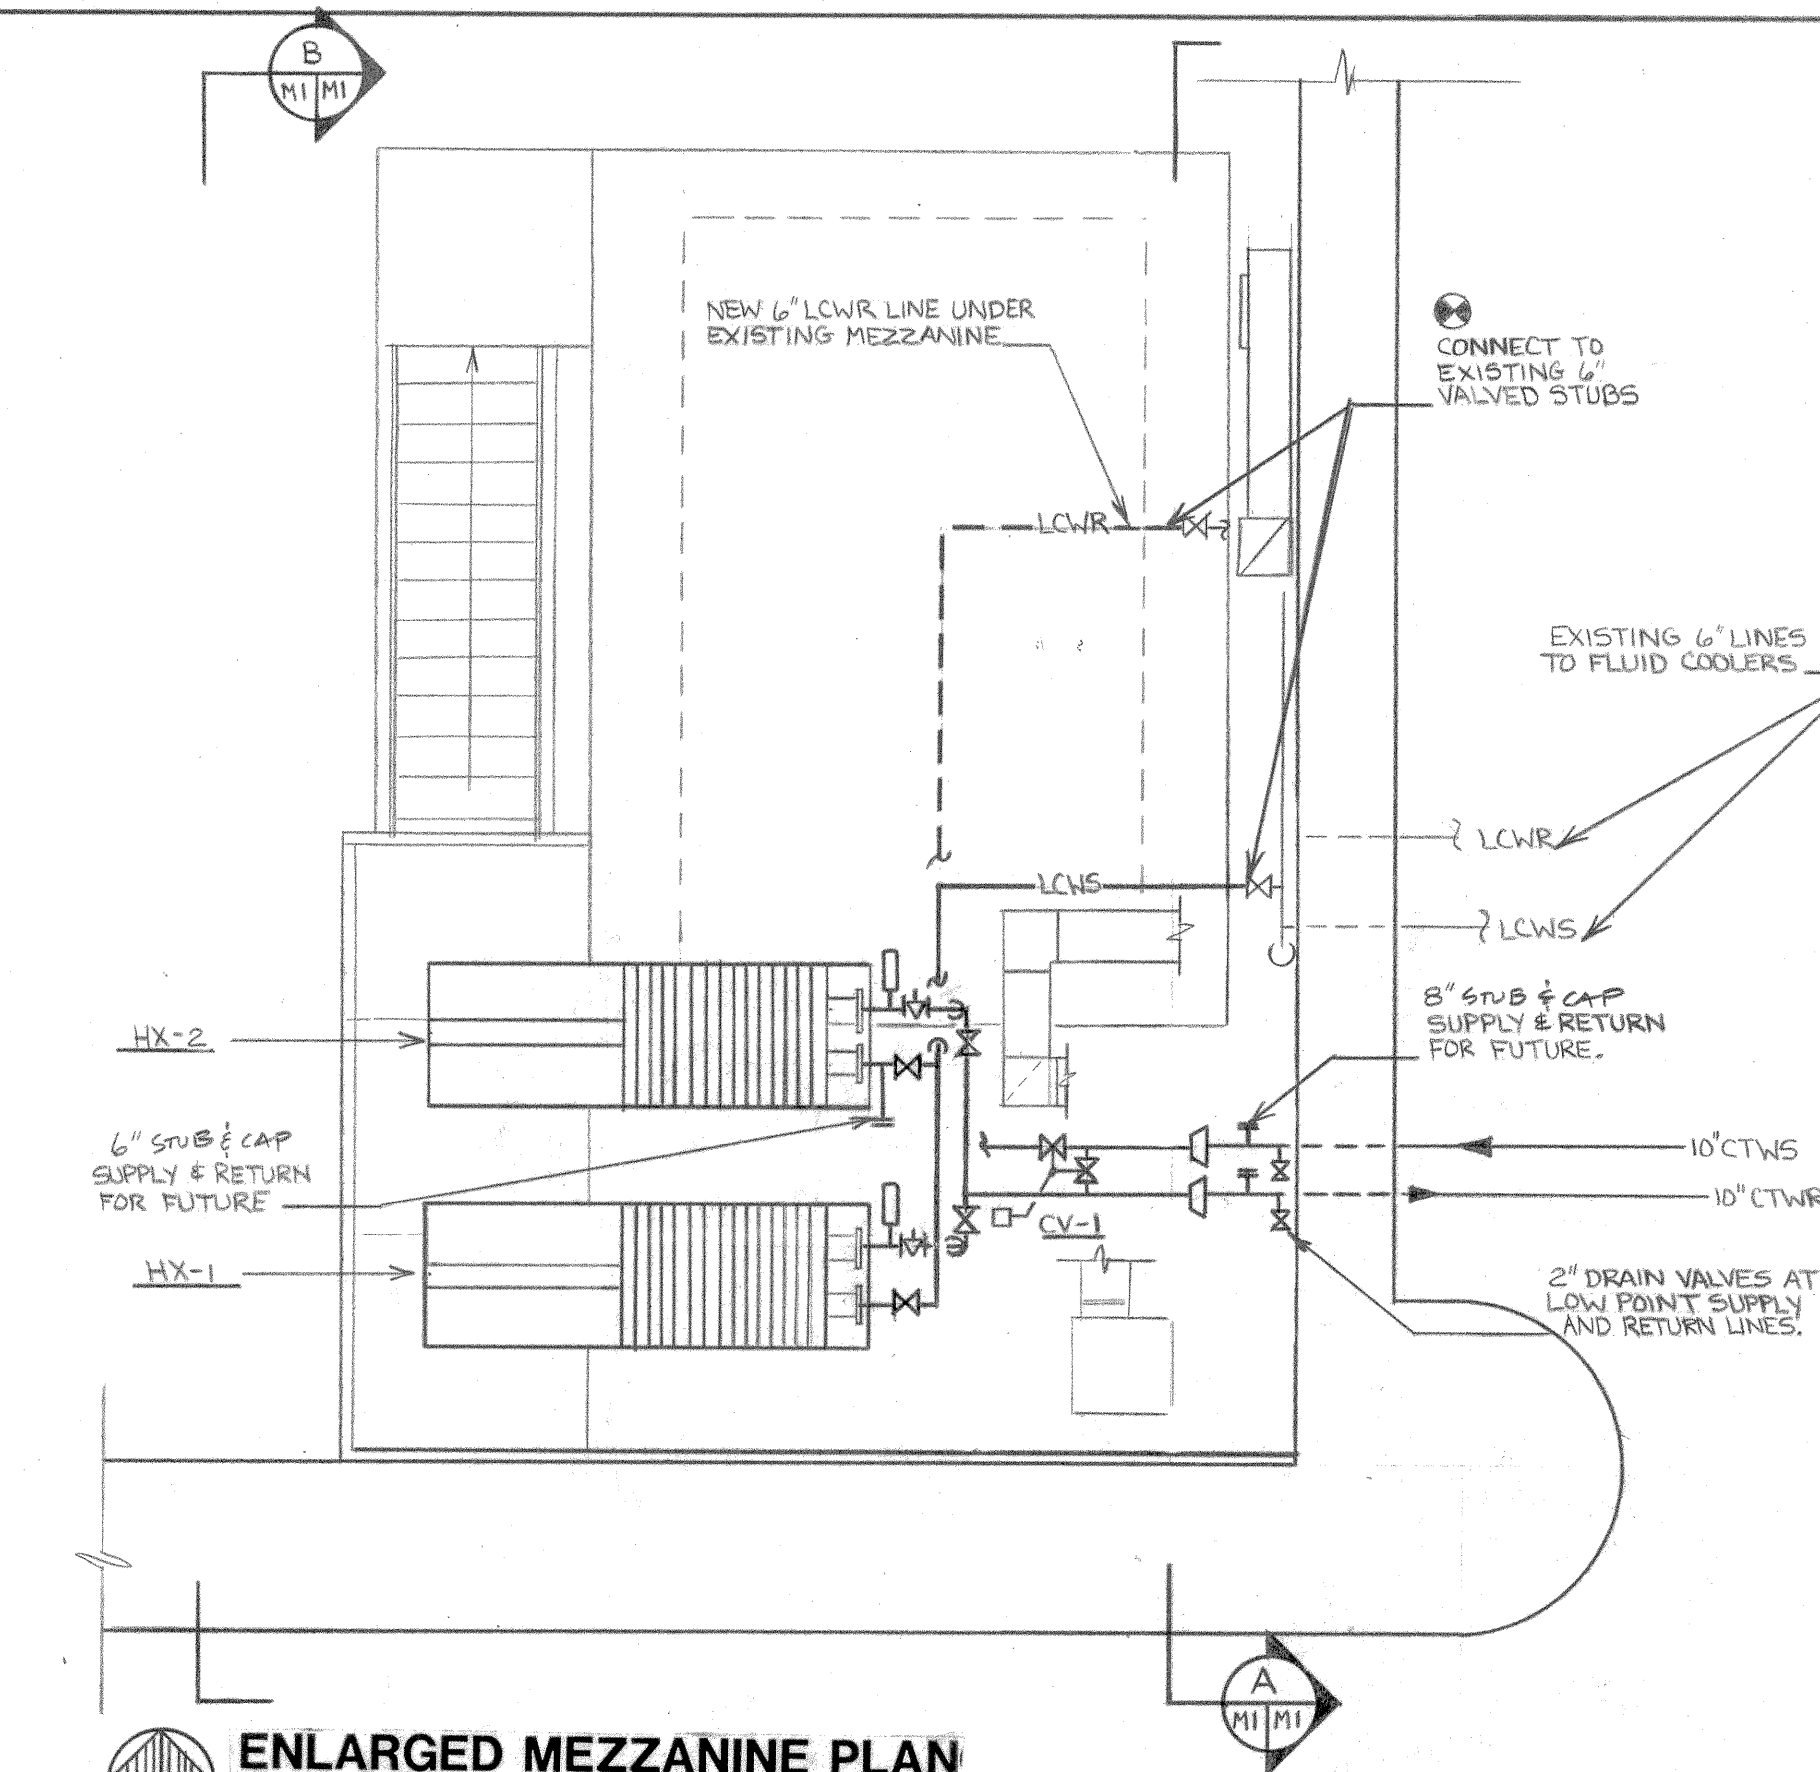

ENLARGED MEZZANINE PLAN
SCALE 1/4" : 1'-0"